



## DESIGN INTENT DRAWING

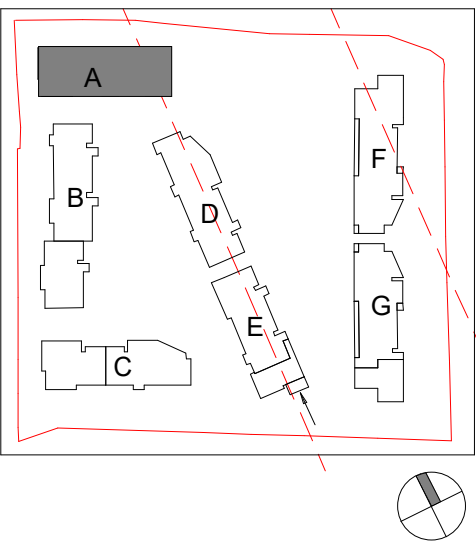

### Room Legend

EH/C	Entrance Hall / Corridor
KLD	Kitchen / Living / Dining Room
BD1	Bedroom 1
BD2	Bedroom 2
BD3	Bedroom 3
BR	Bathroom
BR/ES	Bathroom / En Suite
ES	En Suite
ST	Store
POS	Private Open Space
ER	Electrical Riser
MR	Mechanical Riser
MSV	Mechanical Smoke Vent

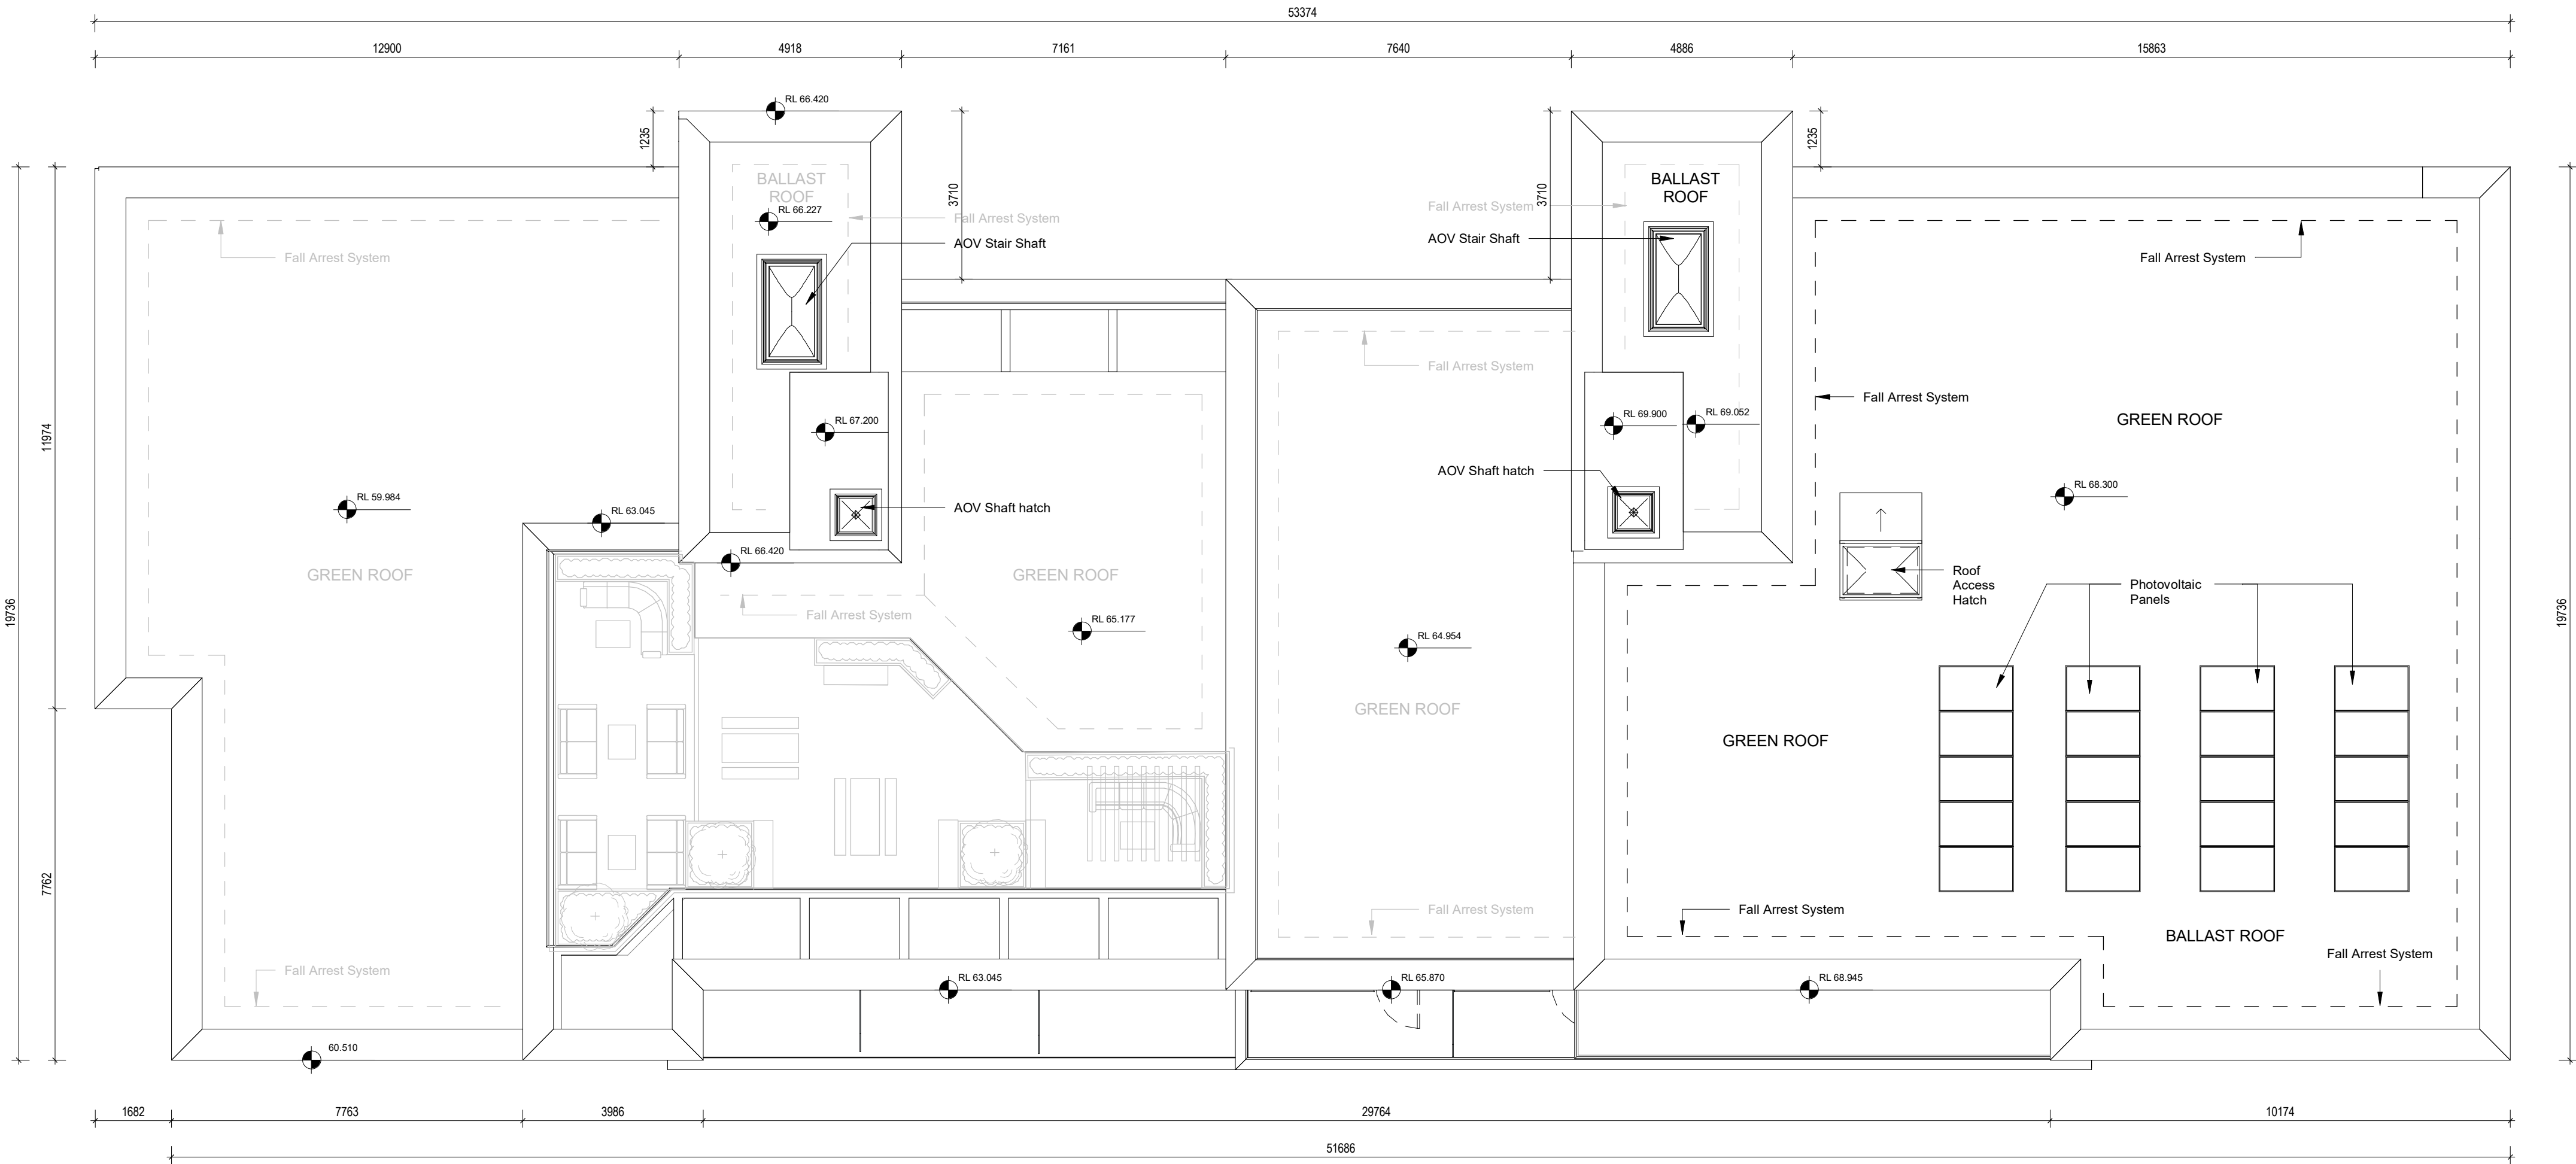

1 GA - Roof Plan  
1 : 100

**PERMITTED SHD**  
(Subject To Conditions)  
Reg Ref: ABP-313289-22

Rev	Description	Date	Dr by	App by
Project Stage				

## PLANNING

Client:  
Eastwise Construction Ltd

Project:  
Hartfield Place  
Swords Road, Whitehall, Dublin 9  
D09 C7F8

Drawing Title:  
BLOCK A - Roof Plan GA - 472 Units

Drawn	Checked	Paper Size	Scale	Date
DP	CM	A1	1 : 100 @A1	Mar. 2022

Project No.	Drawing No.	Classification	Revision
HARTPL	012508		

File Name  
HARTPL-CWO-BA-RL-DR-A-012508

Status:  
S2-Suitable For Information