


DESIGN INTENT DRAWING

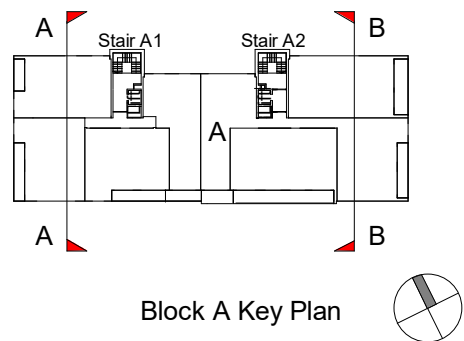

Room Legend

EH/C	Entrance Hall / Corridor
KLD	Kitchen / Living / Dining Room
BD1	Bedroom 1
BD2	Bedroom 2
BD3	Bedroom 3
BR	Bathroom
BR/ES	Bathroom / En Suite
ES	En Suite
ST	Store
POS	Private Open Space
ER	Electrical Riser
MR	Mechanical Riser
MSV	Mechanical Smoke Vent

PERMITTED SHD
(Subject To Conditions)
Reg Ref: ABP-313289-22

Rev	Description	Date	Dr by	App by
-----	-------------	------	-------	--------

Project Stage

PLANNING

Client:

Eastwise Construction Ltd

Project:

Hartfield Place
Swords Road, Whitehall, Dublin 9
D09 C7F8

Drawing Title:

BLOCK A - Section AA and BB GA - 472 Units

Drawn	Checked	Paper Size	Scale	Date
DP	CM	A1	1 : 100 @A1	Mar. 2022


Project No.	Drawing No.	Classification	Revision
HARTPL	012530		

File Name

HARTPL-CWO-BA-ZZ-DR-A-012530


Status:

S2-Suitable For Information

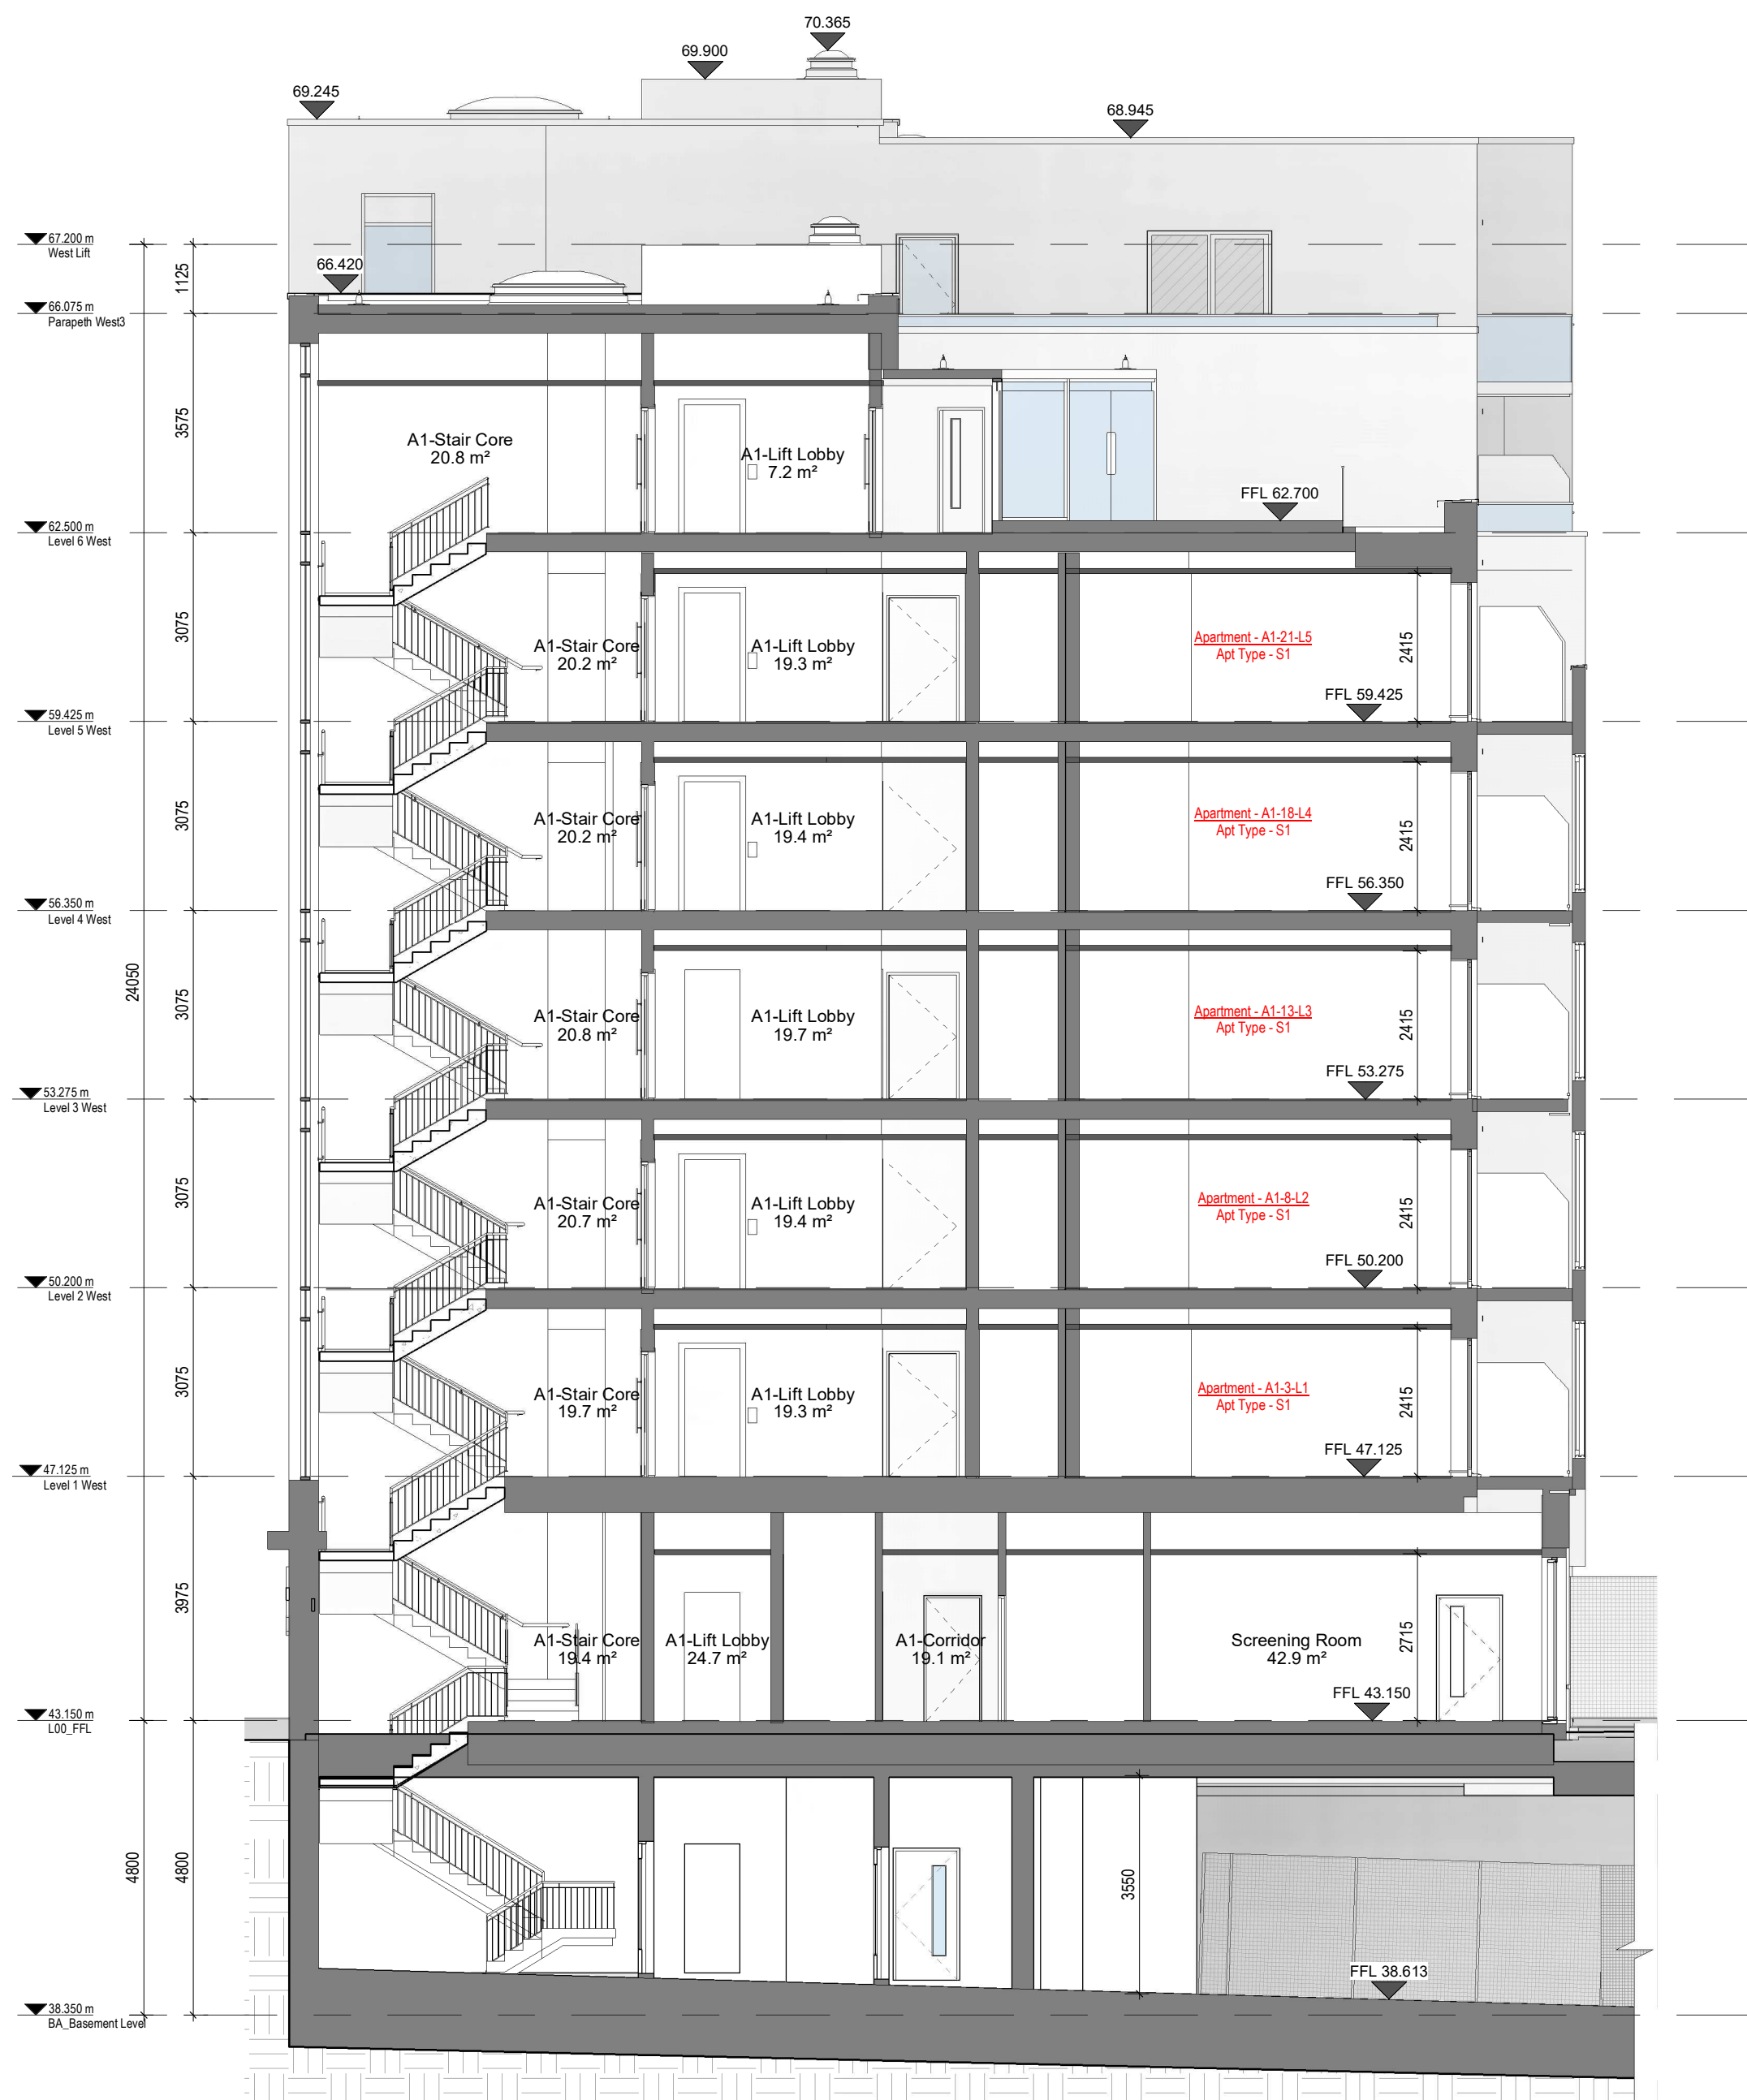

1 GA - Section AA

1 : 100

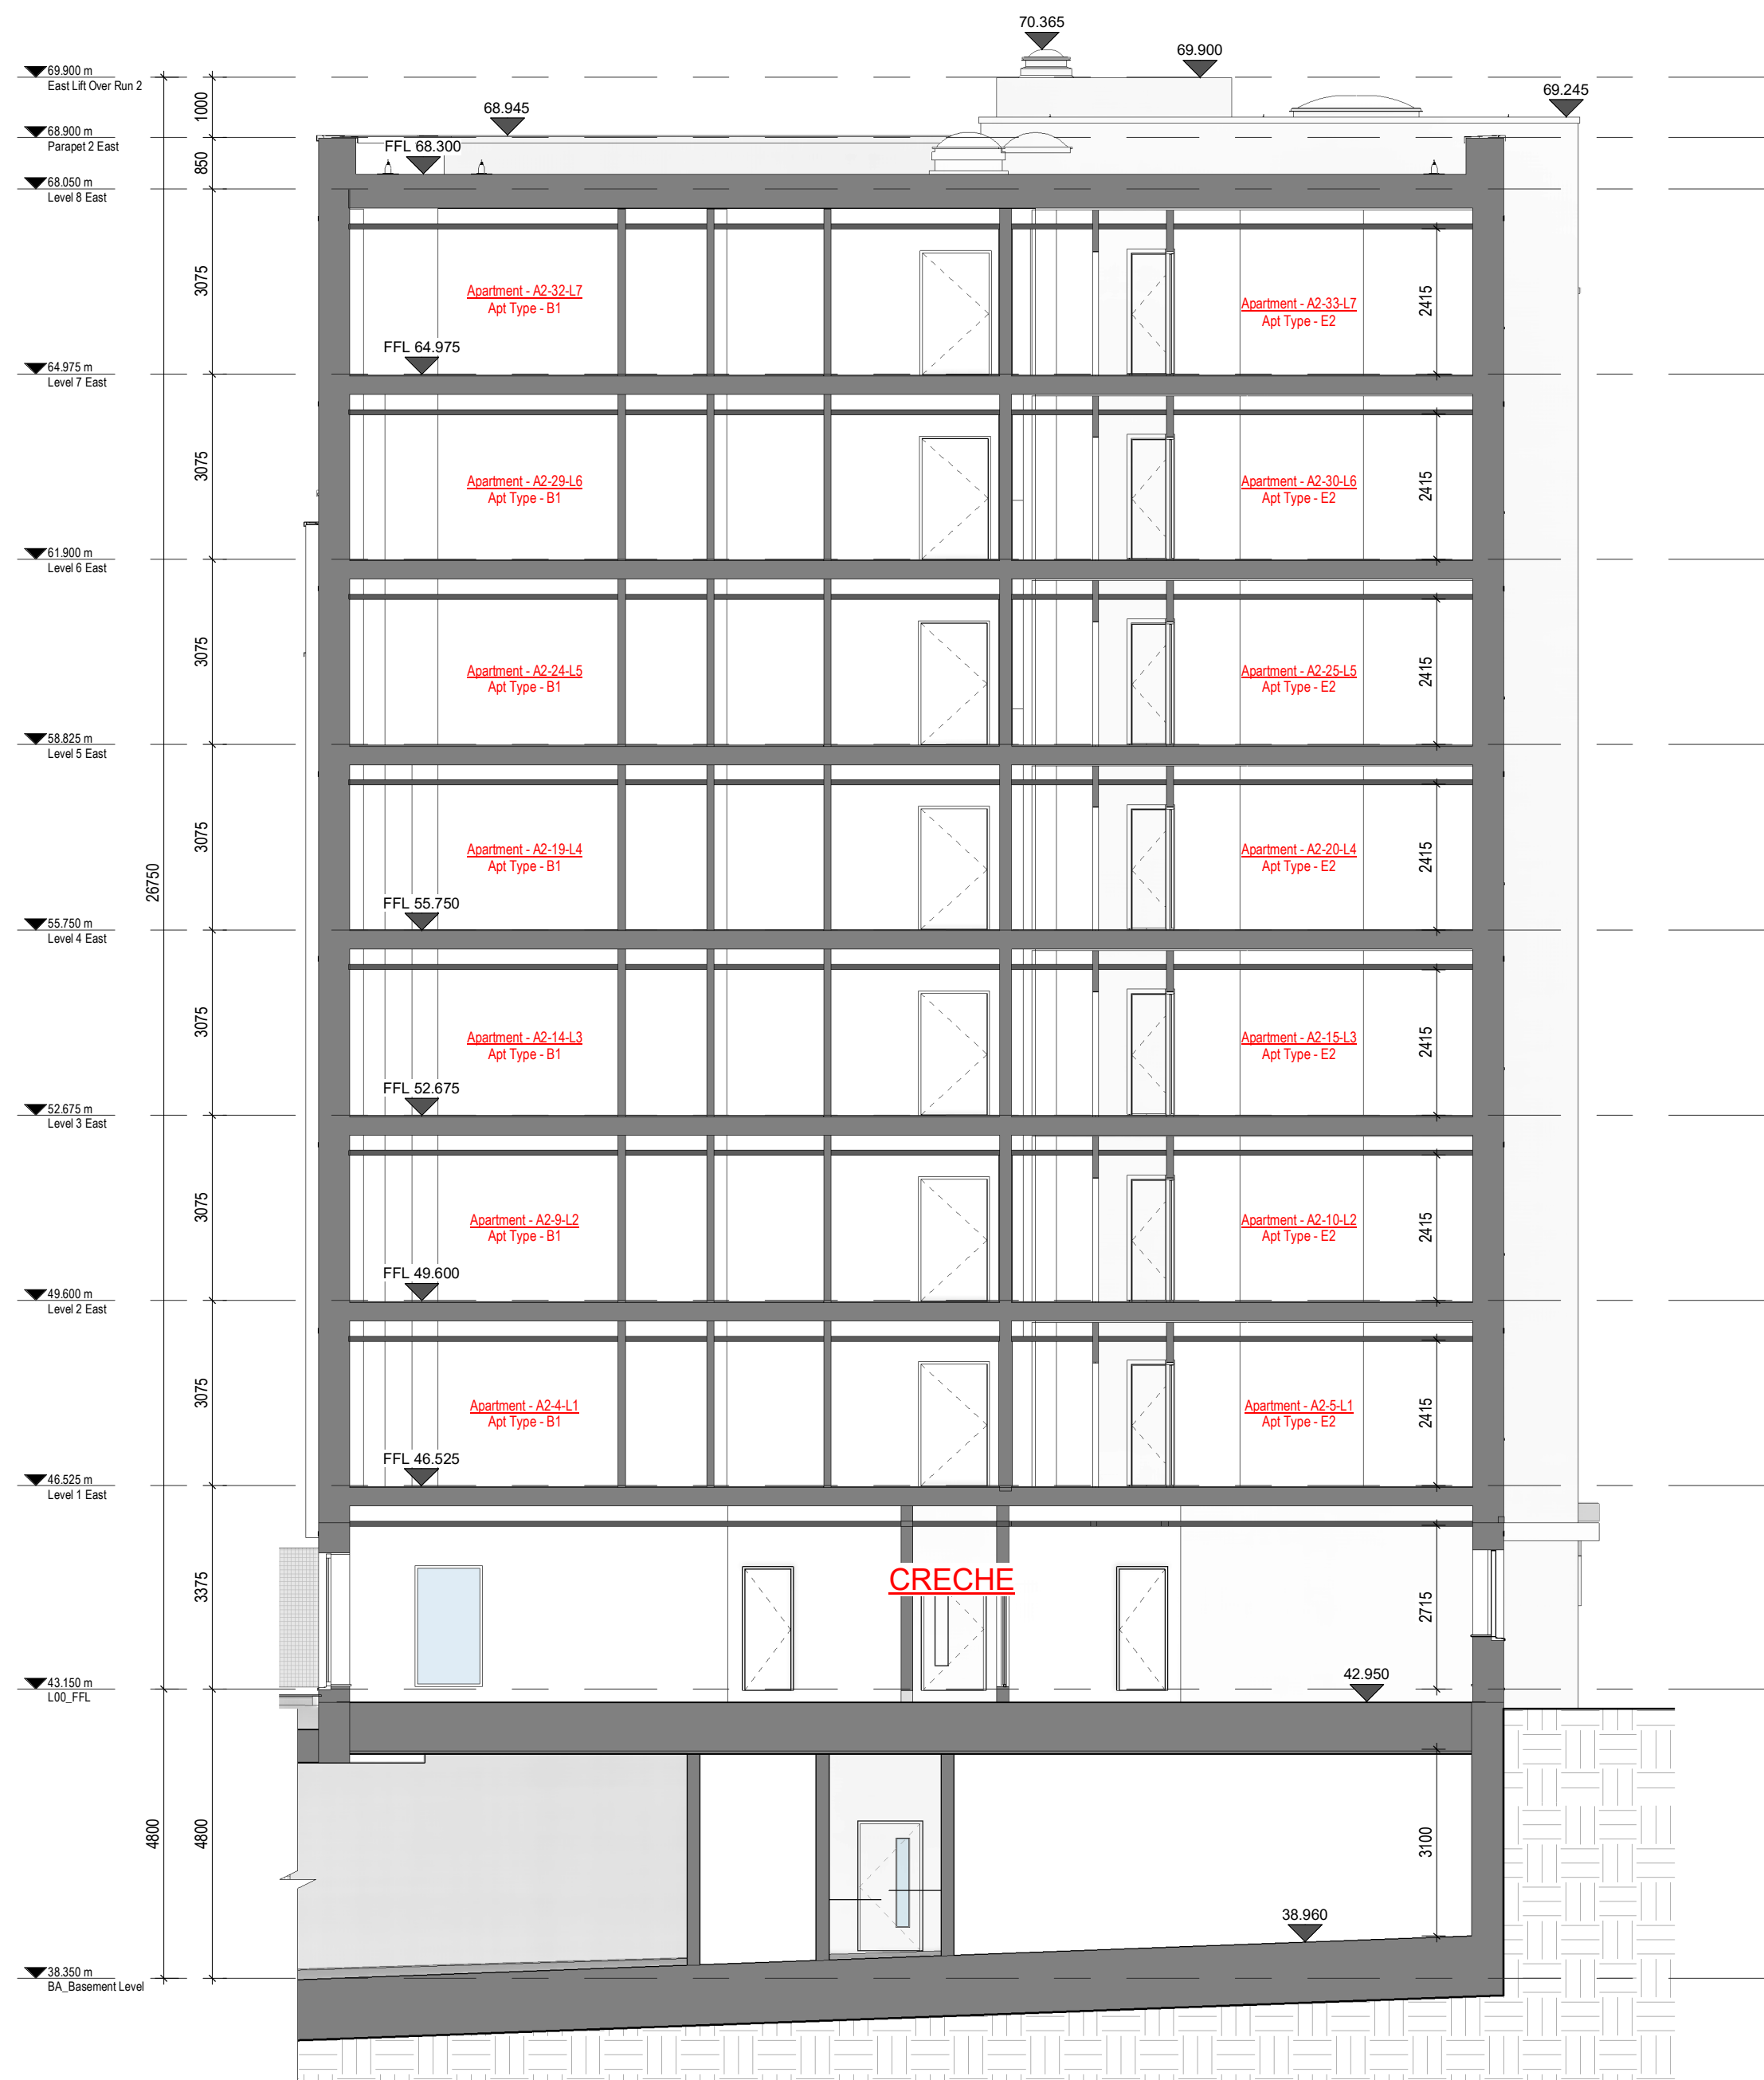

2 GA - Section BB

1 : 100