



DESIGN INTENT DRAWING

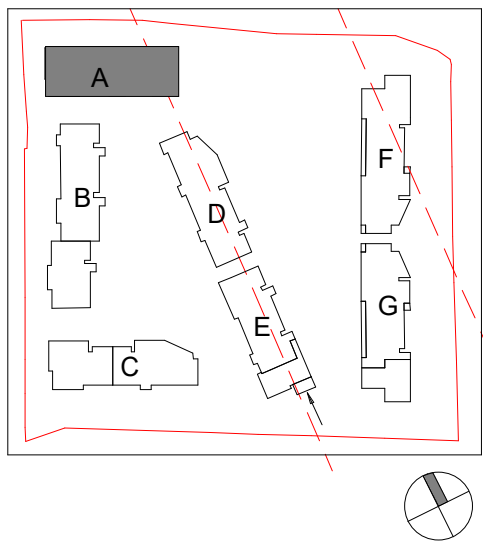

Room Legend

EH/C	Entrance Hall / Corridor
KLD	Kitchen / Living / Dining Room
BD1	Bedroom 1
BD2	Bedroom 2
BD3	Bedroom 3
BR	Bathroom
BR/ES	Bathroom / En Suite
ES	En Suite
ST	Store
POS	Private Open Space
ER	Electrical Riser
MR	Mechanical Riser
MSV	Mechanical Smoke Vent

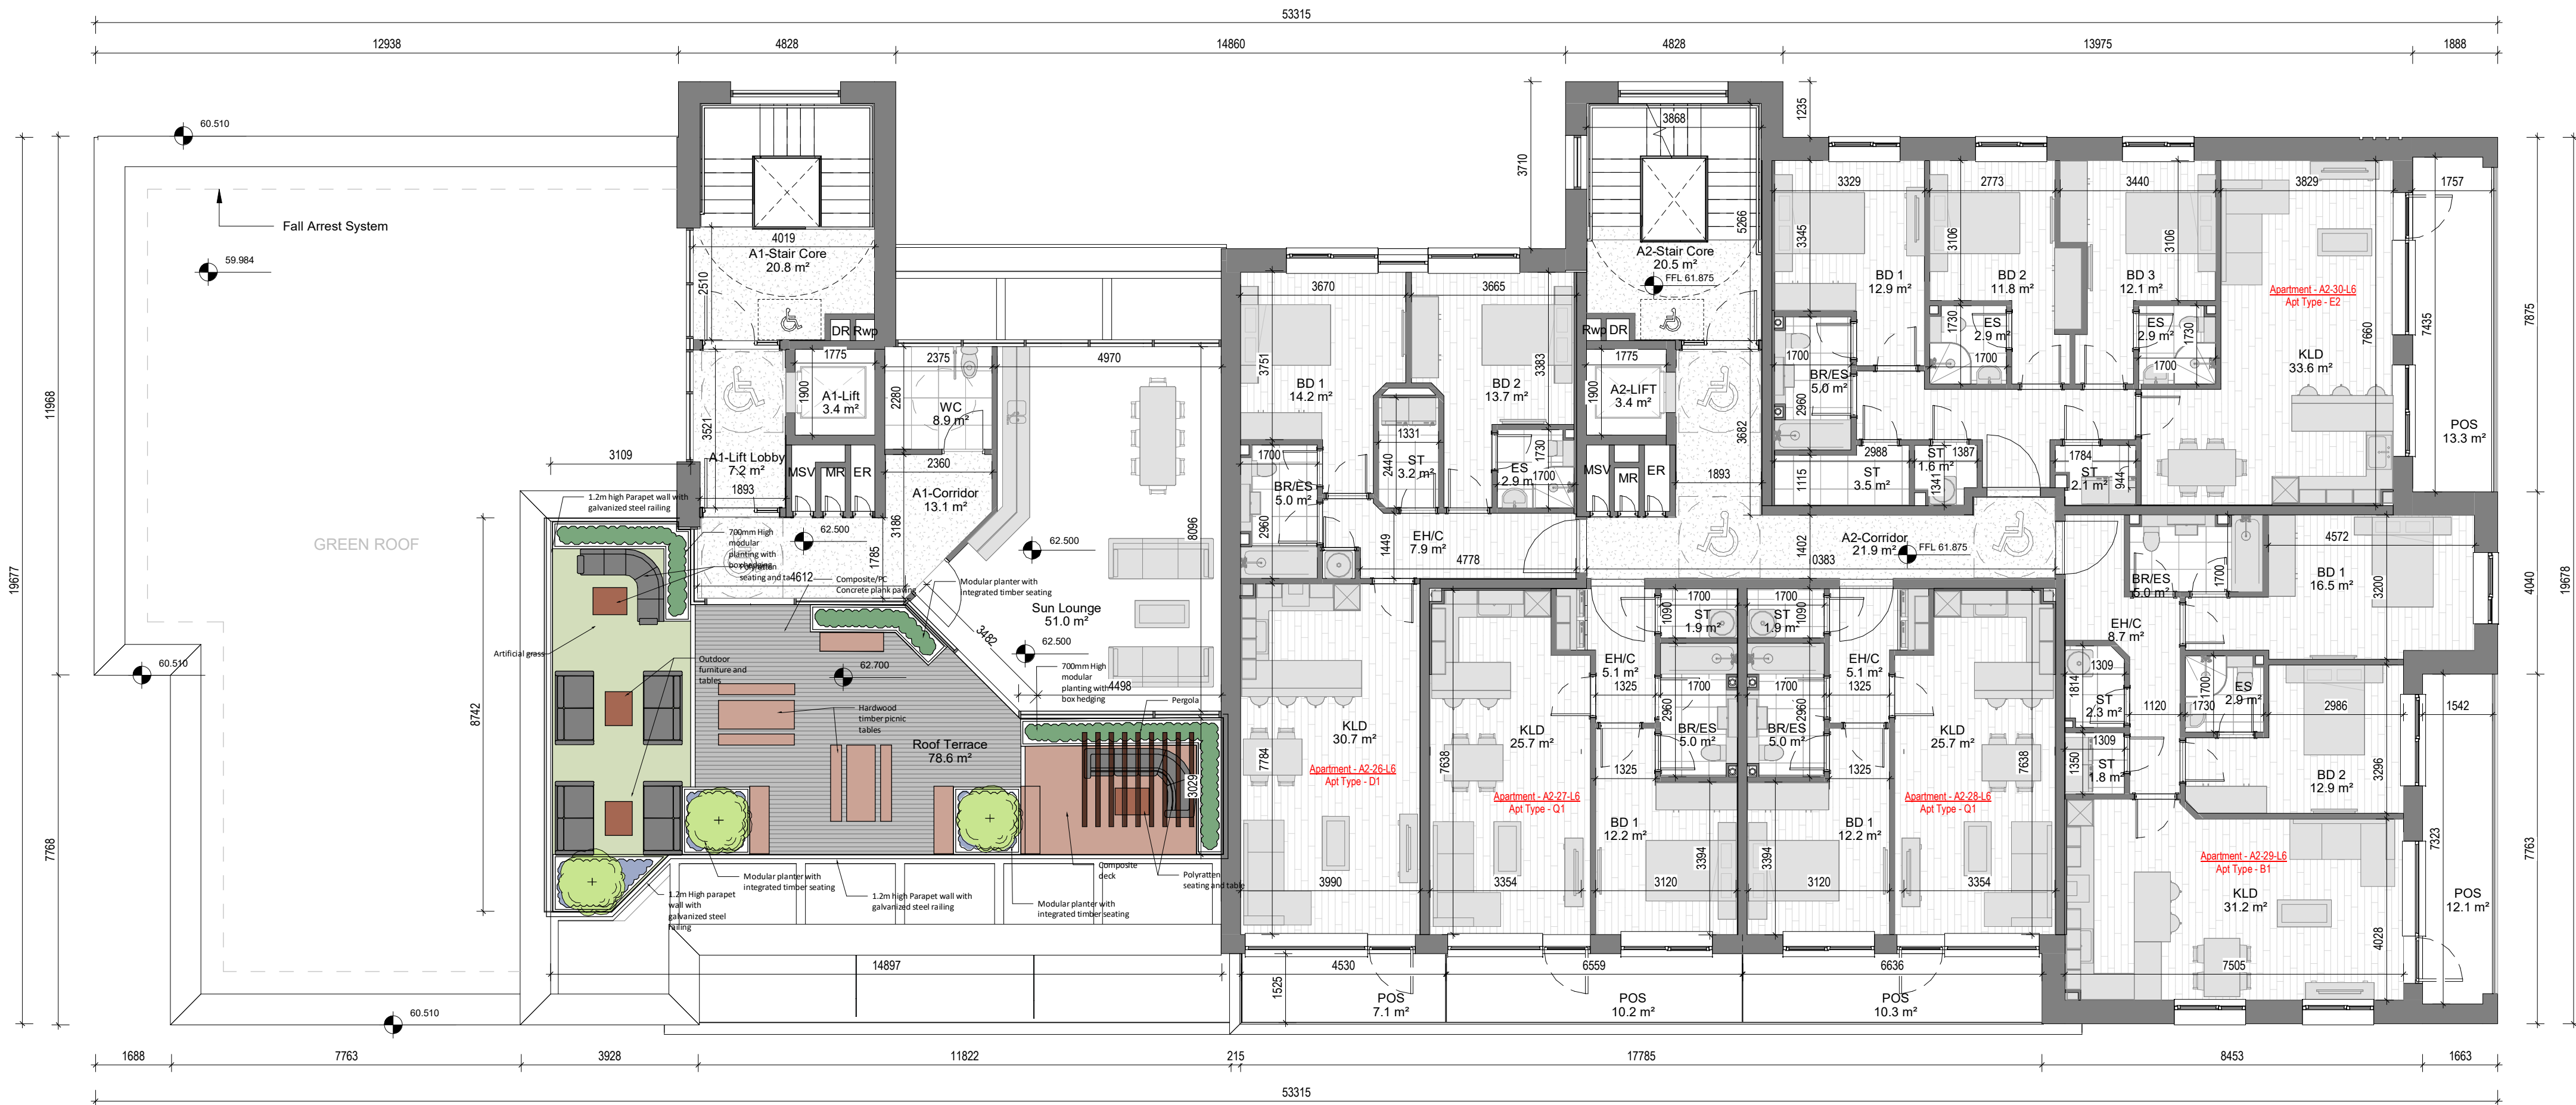

1 GA - Sixth Floor Plan
1 : 100

PERMITTED SHD
(Subject To Conditions)
Reg Ref: ABP-313289-22

Rev	Description	Date	Dr by	App by
Project Stage				

PLANNING

Client:
Eastwise Construction Ltd

Project:
Hartfield Place
Swords Road, Whitehall, Dublin 9
D09 C7F8

Drawing Title:
BLOCK A - Sixth Floor GA - 472 Units

Drawn	Checked	Paper Size	Scale	Date
DP	CM	A1	1 : 100 @A1	Mar. 2022
Project No.	Drawing No.	Classification	Revision	
HARTPL	012506			

File Name:
HARTPL-CWO-BA-06-DR-A-012506

Status:
S2-Suitable For Information