
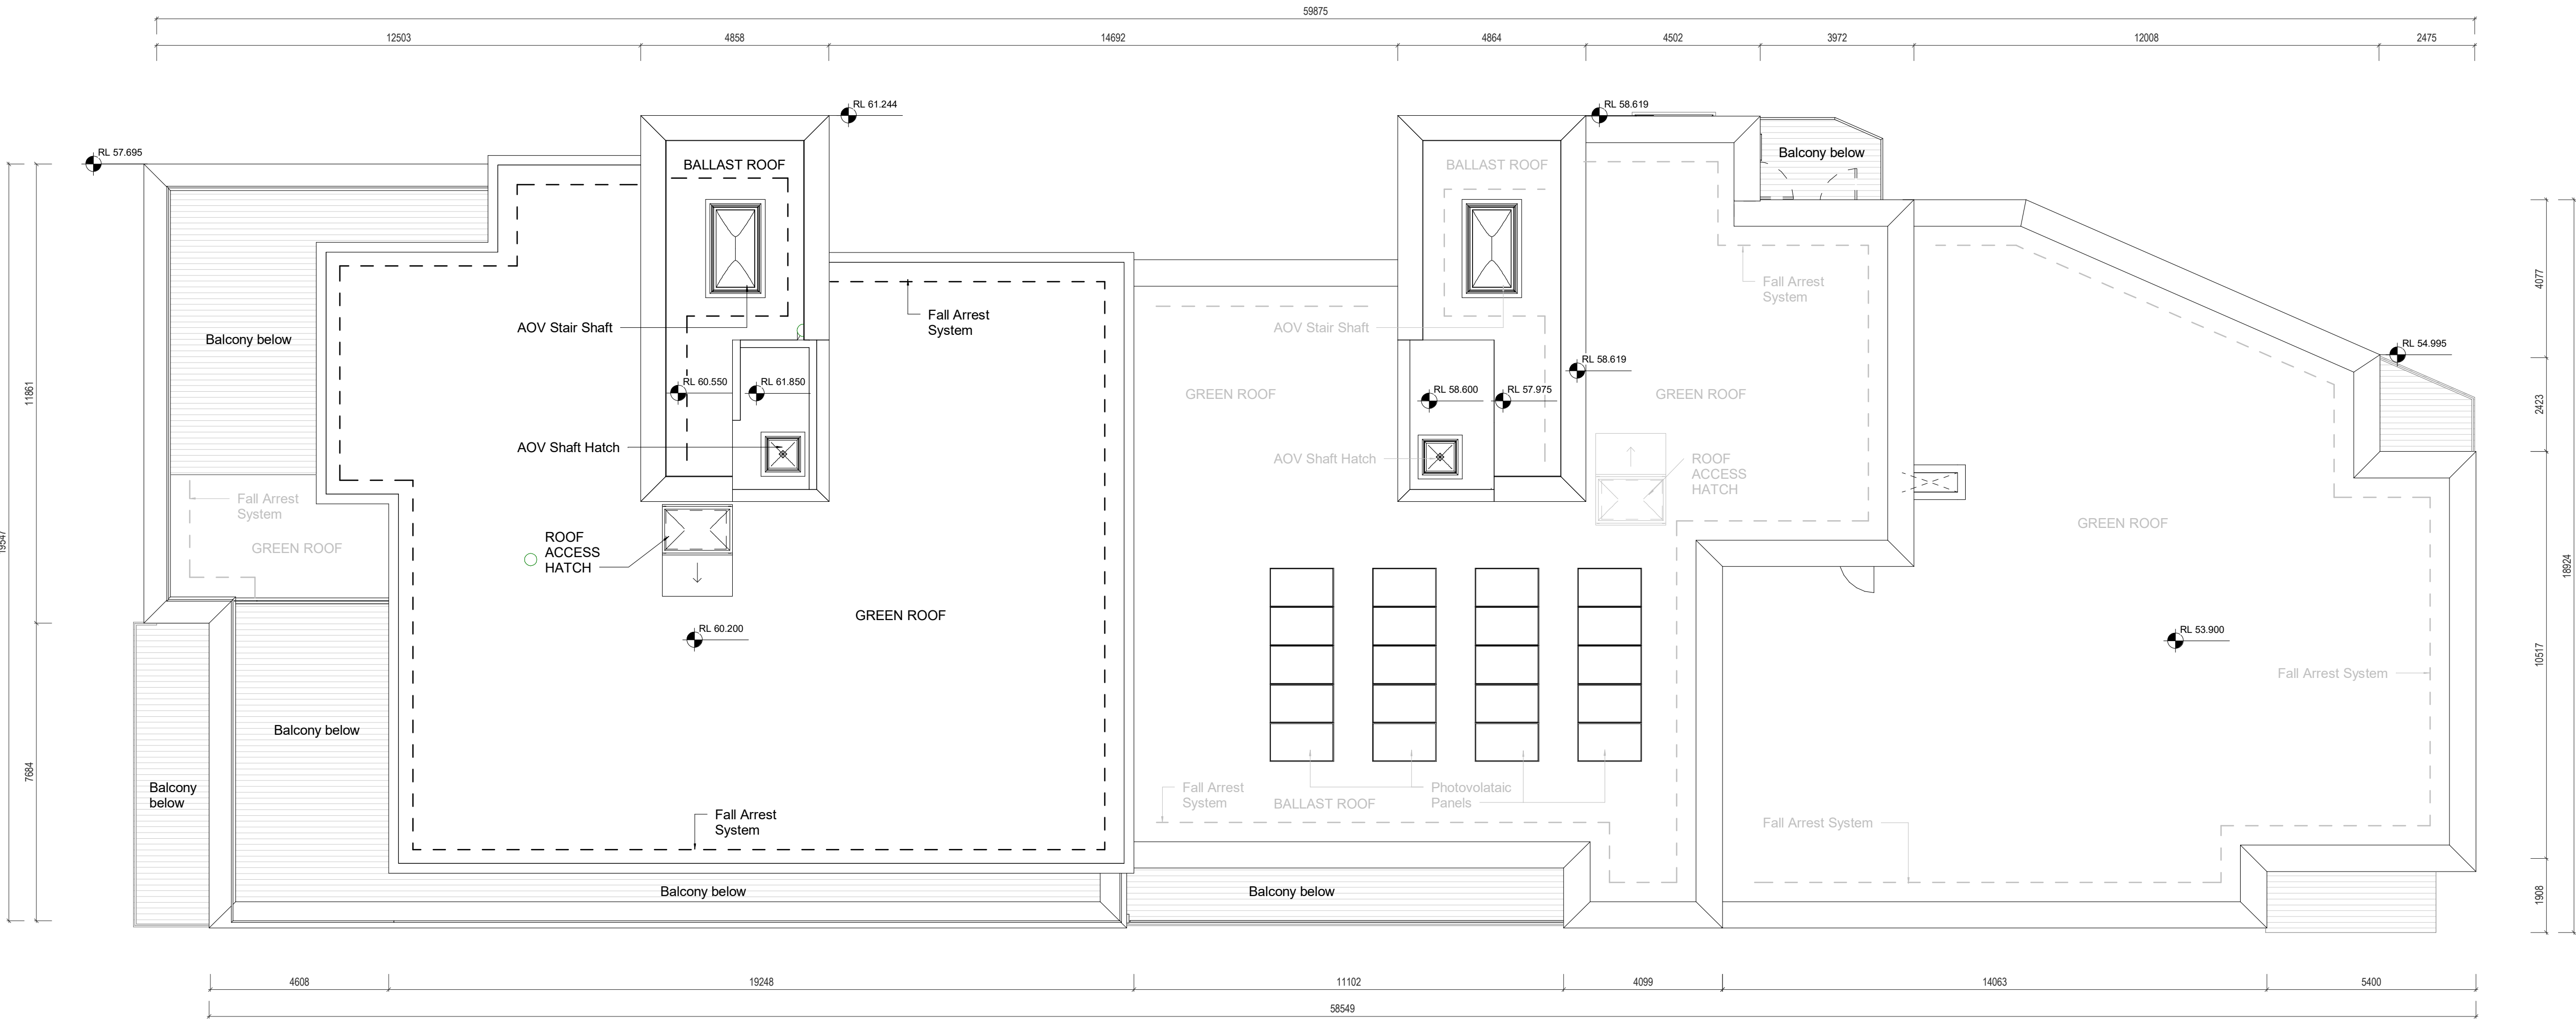


DESIGN INTENT DRAWING

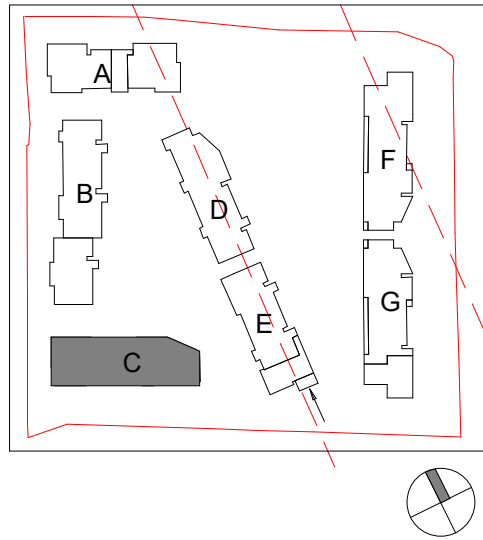

1 GA - Roof Plan

1 : 100

Room Legend

EH/C	Entrance Hall / Corridor
KLD	Kitchen / Living / Dining Room
BD1	Bedroom 1
BD2	Bedroom 2
BD3	Bedroom 3
BR	Bathroom
BR/ES	Bathroom / En Suite
ES	En Suite
ST	Store
POS	Private Open Space
ER	Electrical Riser
MR	Mechanical Riser
MSV	Mechanical Smoke Vent

PERMITTED SHD
(Subject To Conditions)
Reg Ref: ABP-313289-22

Rev	Description	Date	Dr by	App by
-----	-------------	------	-------	--------

Project Stage

PLANNING

Client:

Eastwise Construction Ltd.

Project:

Hartfield Place
Swords Road, Whitehall, Dublin 9
D09 C7F8

Drawing Title:

BLOCK C - Roof Plan GA - 472 Units

Drawn	Checked	Paper Size	Scale	Date
DP	WP	A1	1 : 100 @A1	Mar. 2022

Project No.	Drawing No.	Classification	Revision
HARTPL	032506		

File Name

HARTPL-CWO-BC-RL-DR-A-032506

Status:

S2-Suitable For Information

C+W O'BRIEN
ARCHITECTS

No.1 Sarsfield Quay, Dublin 7, D07 R9FH
t: 01 518 0170 e: admin@cwoarchitects.ie
Dublin | Cork | Galway | London | UK & Europe +
www.cwoarchitects.ie

Please consider the environment before printing this sheet