
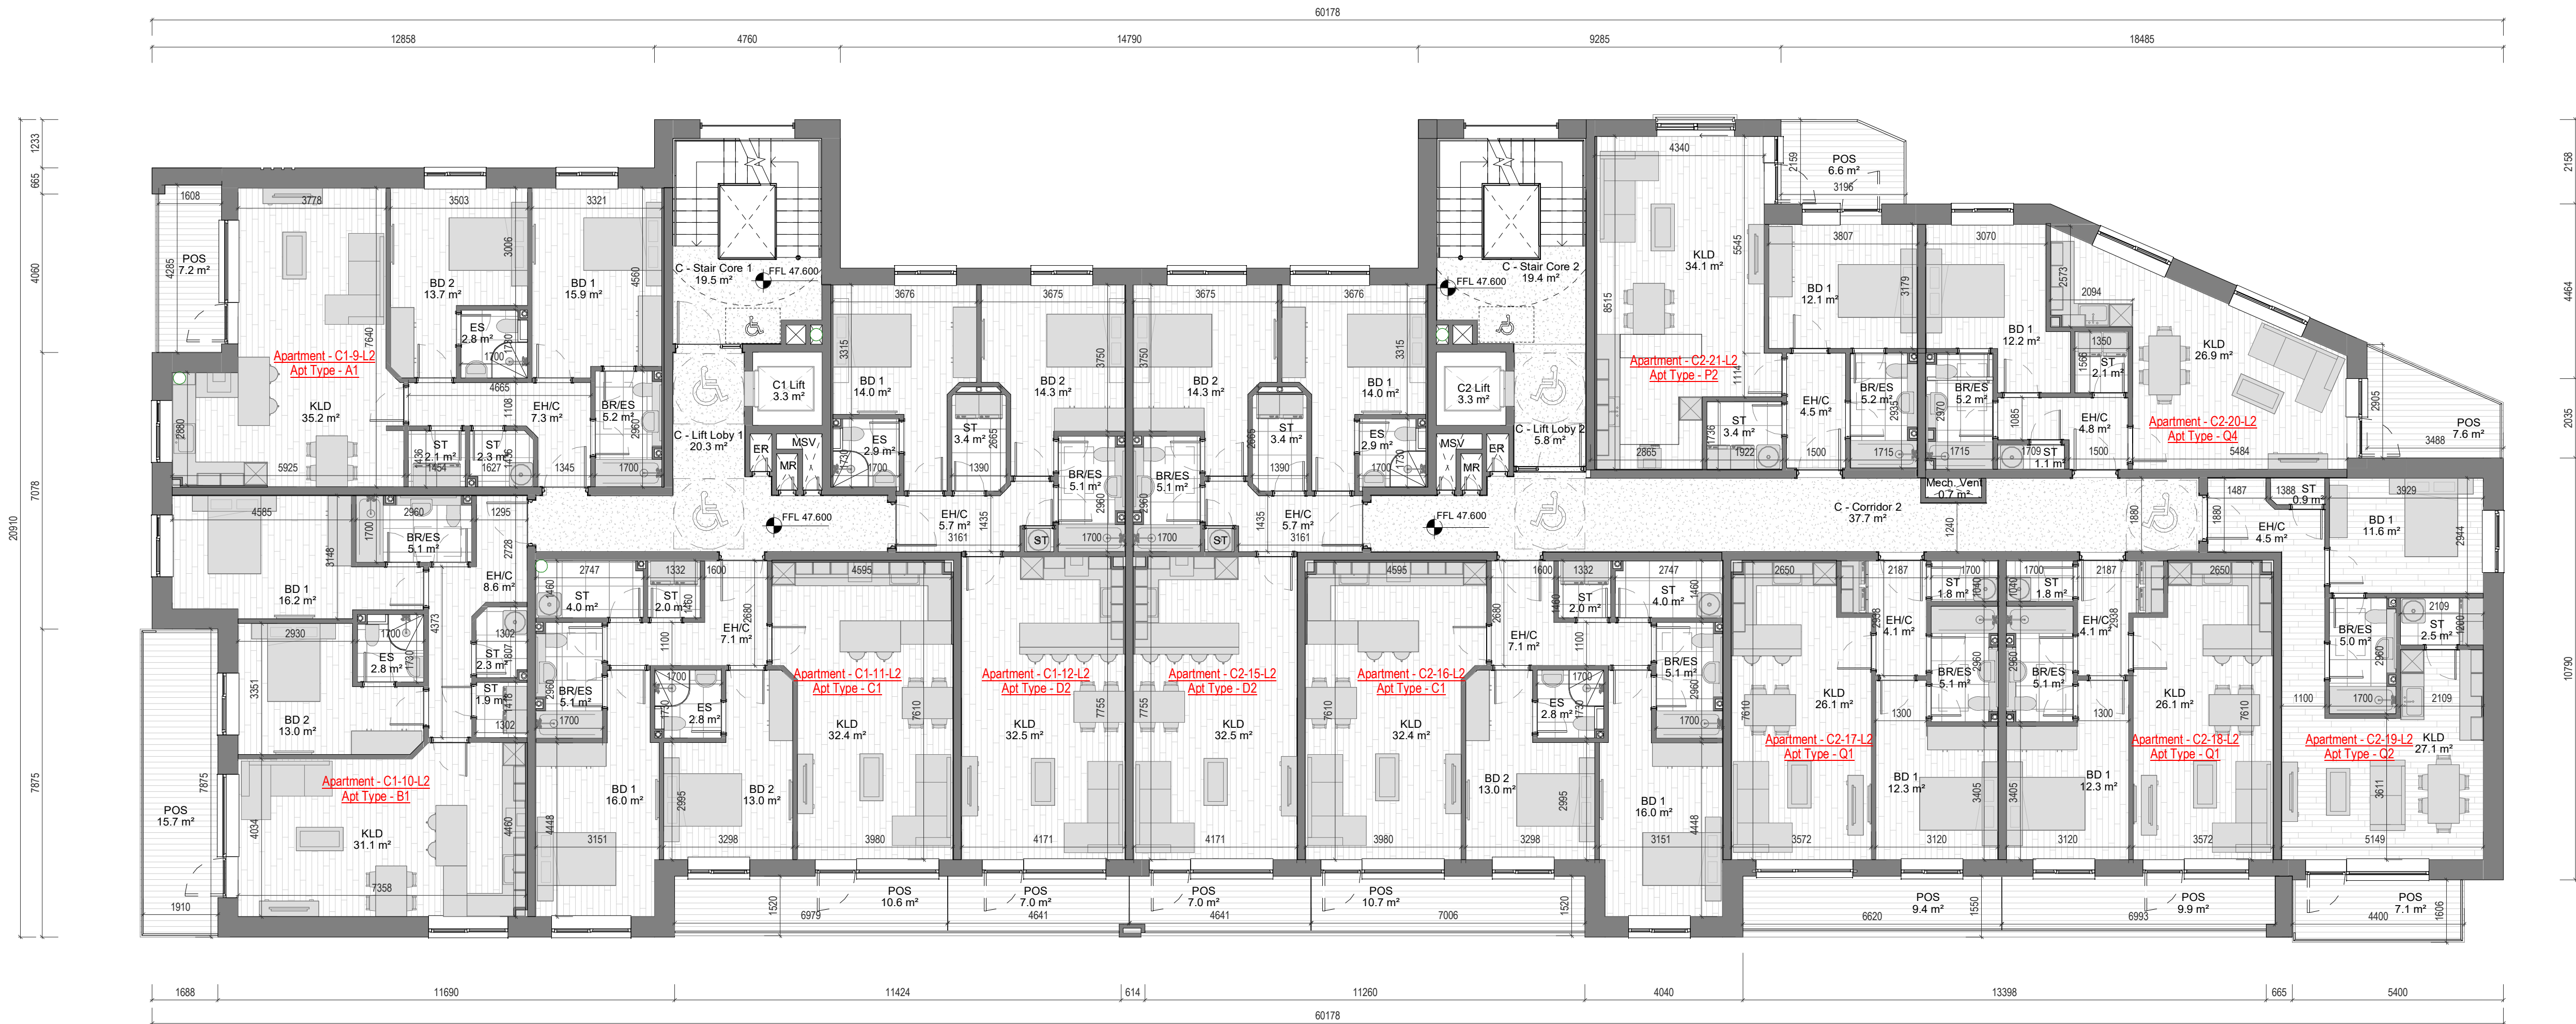


## DESIGN INTENT DRAWING

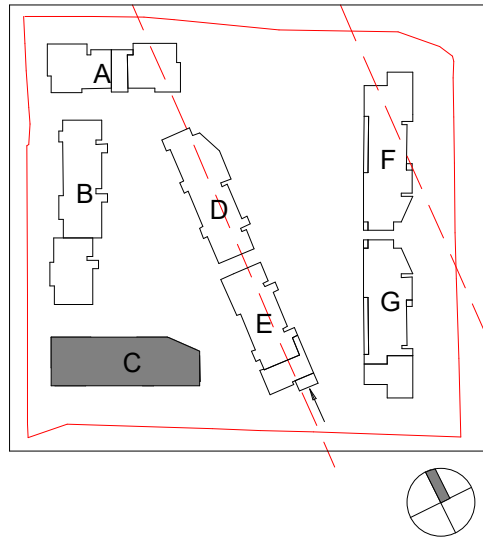

### Room Legend

|       |                                |
|-------|--------------------------------|
| EHC   | Entrance Hall / Corridor       |
| KLD   | Kitchen / Living / Dining Room |
| BD1   | Bedroom 1                      |
| BD2   | Bedroom 2                      |
| BD3   | Bedroom 3                      |
| BR    | Bathroom                       |
| BR/ES | Bathroom / En Suite            |
| ES    | En Suite                       |
| ST    | Store                          |
| POS   | Private Open Space             |
| ER    | Electrical Riser               |
| MR    | Mechanical Riser               |
| MSV   | Mechanical Smoke Vent          |

**PERMITTED SHD**  
(Subject To Conditions)  
Reg Ref: ABP-313289-22

| Rev | Description | Date | Dr by | App by |
|-----|-------------|------|-------|--------|
|-----|-------------|------|-------|--------|

Project Stage

## PLANNING

Client:

Eastwise Construction Ltd.

Project:

Hartfield Place  
Swords Road, Whitehall, Dublin 9  
D09 C7F8

Drawing Title:

BLOCK C - Second Floor GA - 472 Units

| Drawn | Checked | Paper Size | Scale       | Date      |
|-------|---------|------------|-------------|-----------|
| DP    | WP      | A1         | 1 : 100 @A1 | Mar. 2022 |

| Project No. | Drawing No. | Classification | Revision |
|-------------|-------------|----------------|----------|
| HARTPL      | 032502      |                |          |

File Name  
HARTPL-CWO-BC-02-DR-A-032502

Status:  
S2-Suitable For Information

**C+W O'BRIEN**  
ARCHITECTS

No.1 Sarsfield Quay, Dublin 7, D07 R9FH  
t: 01 518 0170 e: admin@cwoarchitects.ie  
Dublin | Cork | Galway | London | UK & Europe +  
www.cwoarchitects.ie

Please consider the environment before printing this sheet

1 GA - Second Floor Plan

1 : 100