



## DESIGN INTENT DRAWING

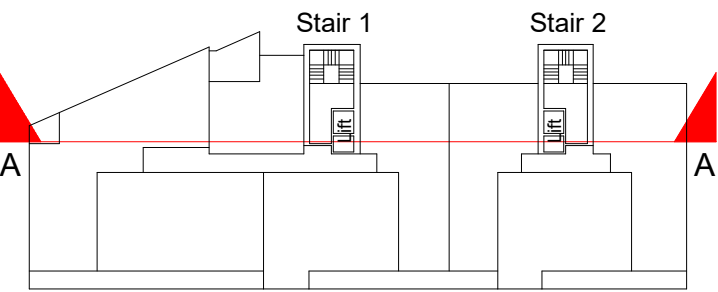

Key Plan (NTS)

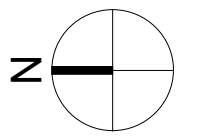

### Room Legend

|       |                                |
|-------|--------------------------------|
| EH/C  | Entrance Hall / Corridor       |
| KLD   | Kitchen / Living / Dining Room |
| BD1   | Bedroom 1                      |
| BD2   | Bedroom 2                      |
| BD3   | Bedroom 3                      |
| BR    | Bathroom                       |
| BR/ES | Bathroom / En Suite            |
| ES    | En Suite                       |
| ST    | Store                          |
| POS   | Private Open Space             |
| ER    | Electrical Riser               |
| MR    | Mechanical Riser               |
| MSV   | Mechanical Smoke Vent          |

**PERMITTED SHD**  
(Subject To Conditions)  
Reg Ref: ABP-313289-22

| Rev | Date | Description | Issued By |
|-----|------|-------------|-----------|
|-----|------|-------------|-----------|

Project Stage

**PLANNING**

Client:  
Eastwise Construction Ltd

Project:  
Hartfield Place  
Swords Road, Whitehall, Dublin 9  
D09 C7F8

Drawing Title:  
BLOCK D - Section AA GA - 472 Units

|             |               |                  |                     |                   |
|-------------|---------------|------------------|---------------------|-------------------|
| Drawn<br>DP | Checked<br>CM | Paper Size<br>A1 | Scale<br>1 : 100@A1 | Date<br>Mar. 2022 |
|-------------|---------------|------------------|---------------------|-------------------|

|                       |                       |                |          |
|-----------------------|-----------------------|----------------|----------|
| Project No.<br>HARTPL | Drawing No.<br>042530 | Classification | Revision |
|-----------------------|-----------------------|----------------|----------|


File Name  
HARTPL-CWO-BD-ZZ-DR-A-042530

Status:  
**S2-Suitable For Information**

**C+W O'BRIEN**  
ARCHITECTS

No.1 Sarsfield Quay, Dublin 7, D07 R9FH  
t: 01 518 0170 e: admin@cwoarchitects.ie  
Dublin | Cork | Galway | London | UK & Europe +  
www.cwoarchitects.ie

Please consider the environment before printing this sheet

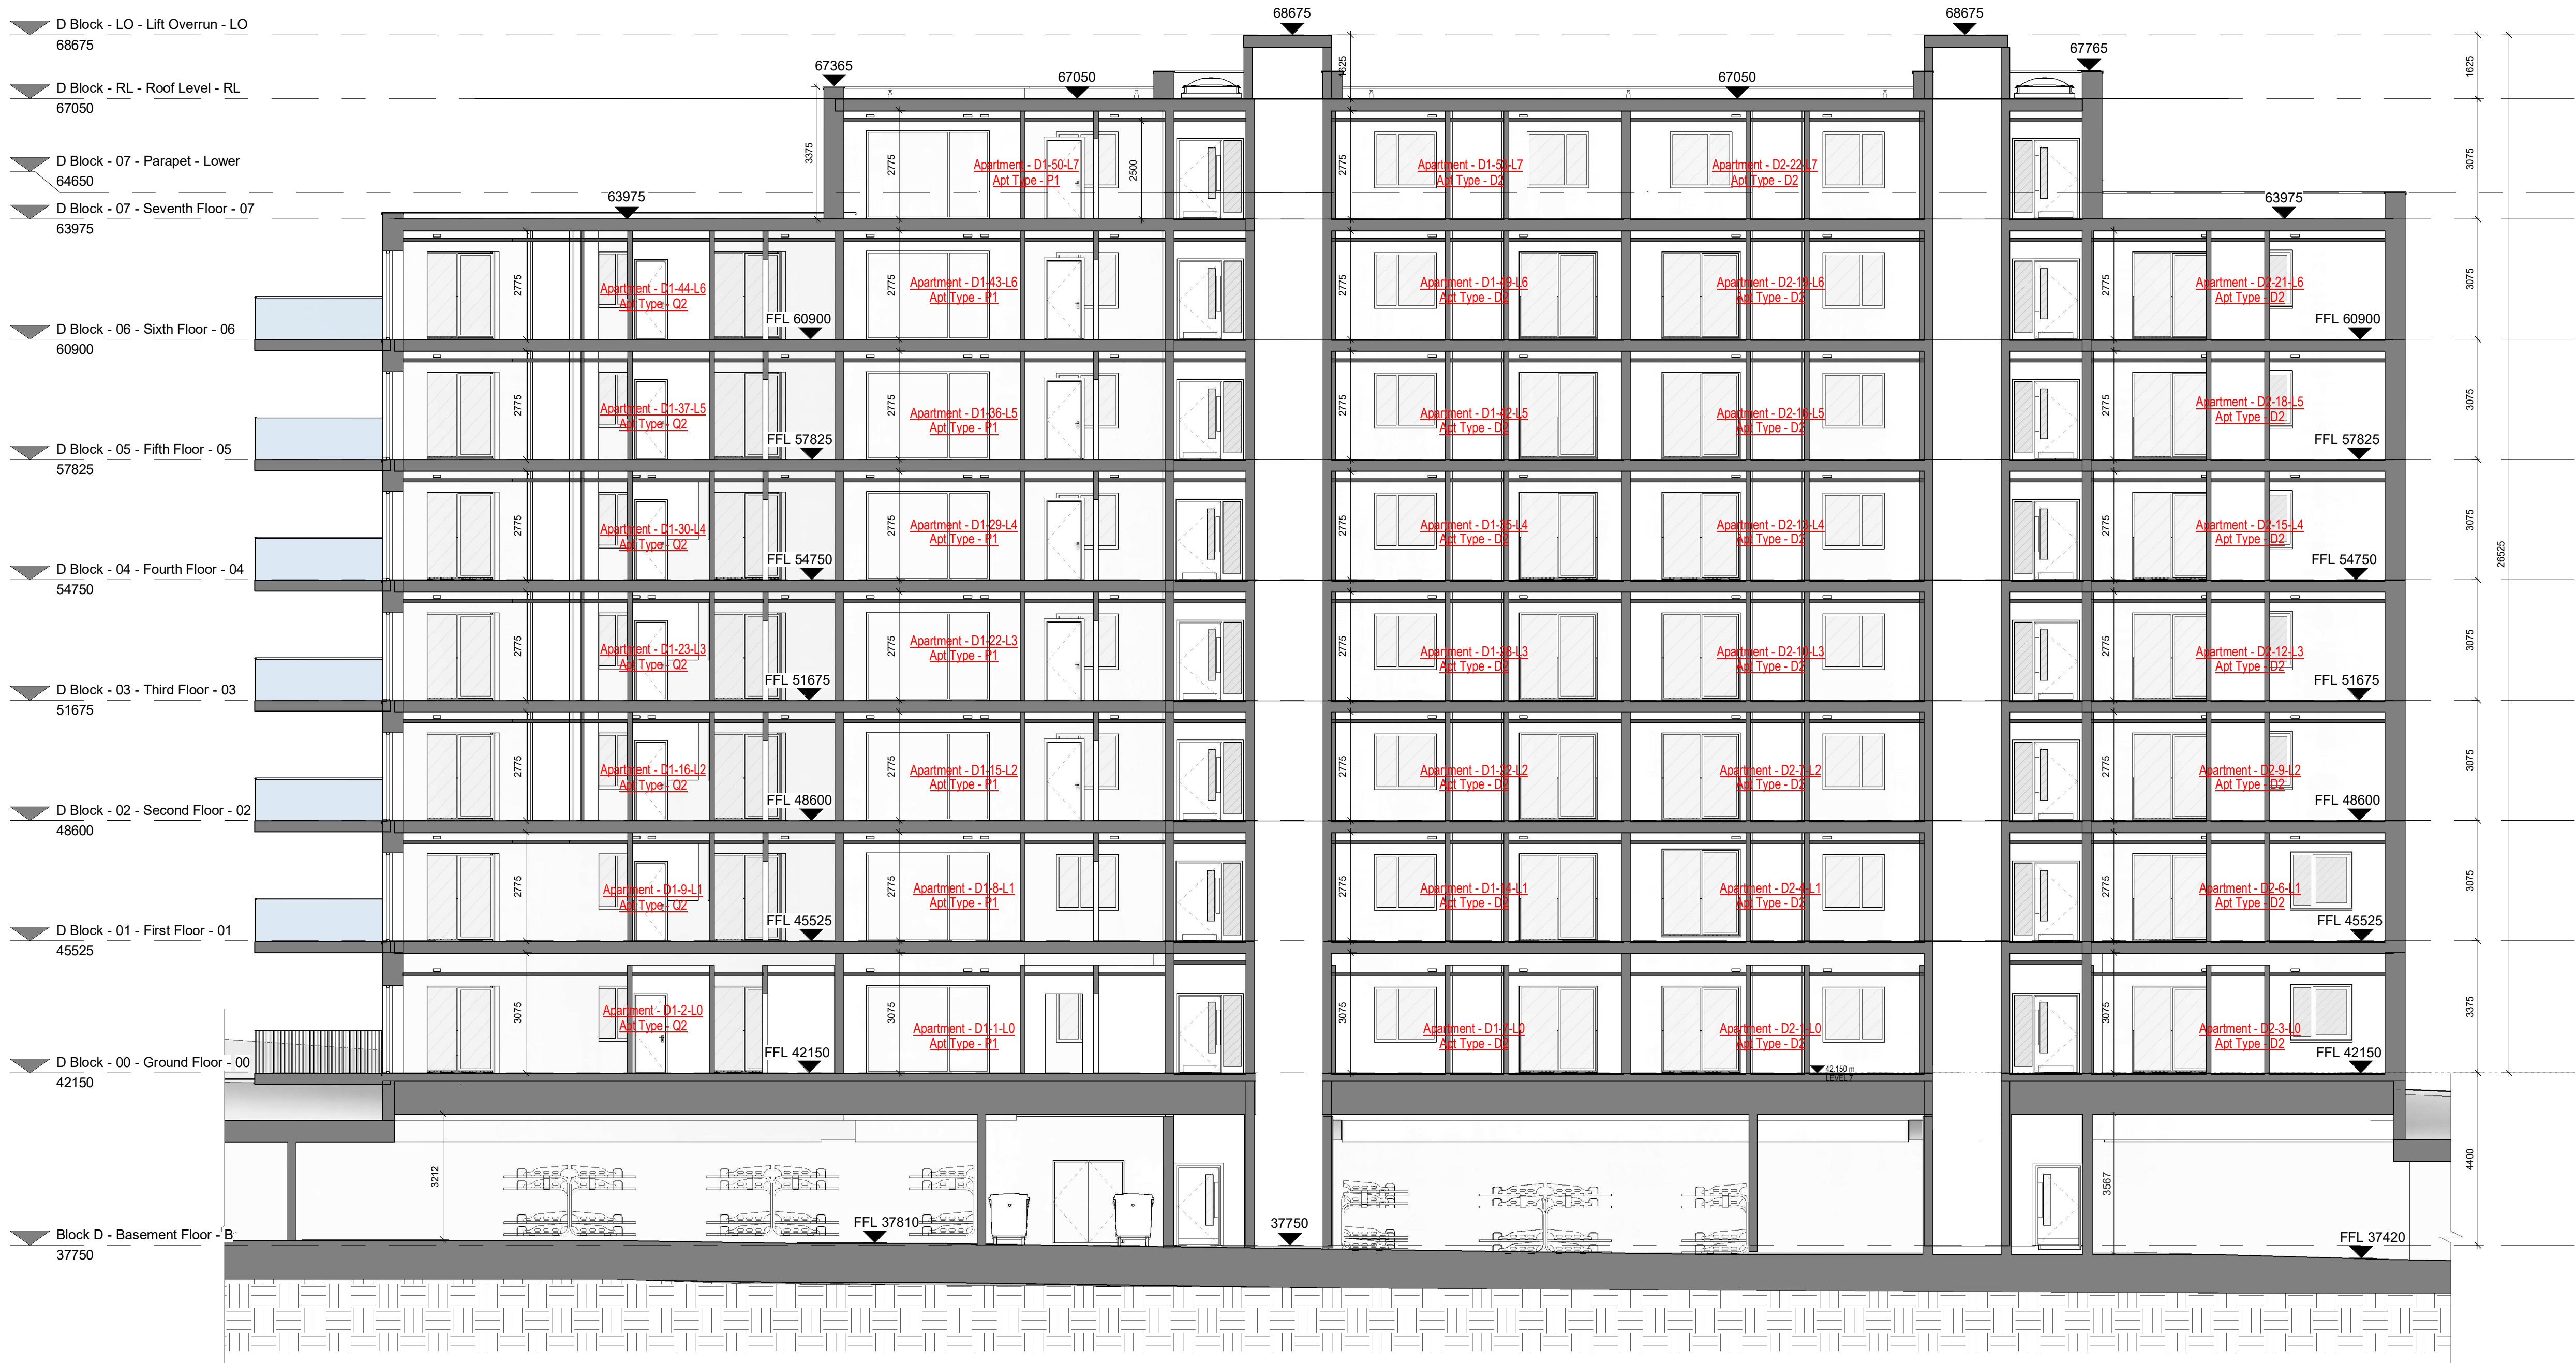

1 GA - Section AA

1 : 100