



DESIGN INTENT DRAWING

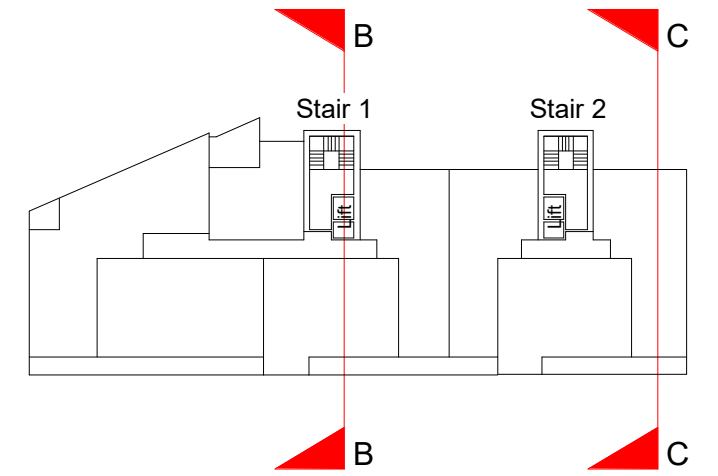

Key Plan (NTS)

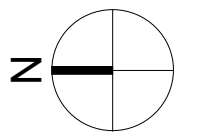

Room Legend

EH/C	Entrance Hall / Corridor
KLD	Kitchen / Living / Dining Room
BD1	Bedroom 1
BD2	Bedroom 2
BD3	Bedroom 3
BR	Bathroom
BR/ES	Bathroom / En Suite
ES	En Suite
ST	Store
POS	Private Open Space
ER	Electrical Riser
MR	Mechanical Riser
MSV	Mechanical Smoke Vent

PERMITTED SHD
(Subject To Conditions)
Reg Ref: ABP-313289-22

Rev	Date	Description	Issued By
-----	------	-------------	-----------

Project Stage

PLANNING

Client:
Eastwise Construction Ltd

Project:
Hartfield Place
Swords Road, Whitehall, Dublin 9
D09 C7F8

Drawing Title:
BLOCK D - Section BB and CC GA - 472 Units

Drawn	Checked	Paper Size	Scale	Date
DP	CM	A1	1 : 100@A1	Mar. 2022

Project No.	Drawing No.	Classification	Revision
HARTPL	042531		


File Name
HARTPL-CWO-BD-ZZ-DR-A-042531

Status:
S2-Suitable For Information

C+W O'BRIEN
ARCHITECTS


No.1 Sarsfield Quay, Dublin 7, D07 R9FH
t: 01 518 0170 e: admin@cwoarchitects.ie
Dublin | Cork | Galway | London | UK & Europe +
www.cwoarchitects.ie

Please consider the environment before printing this sheet

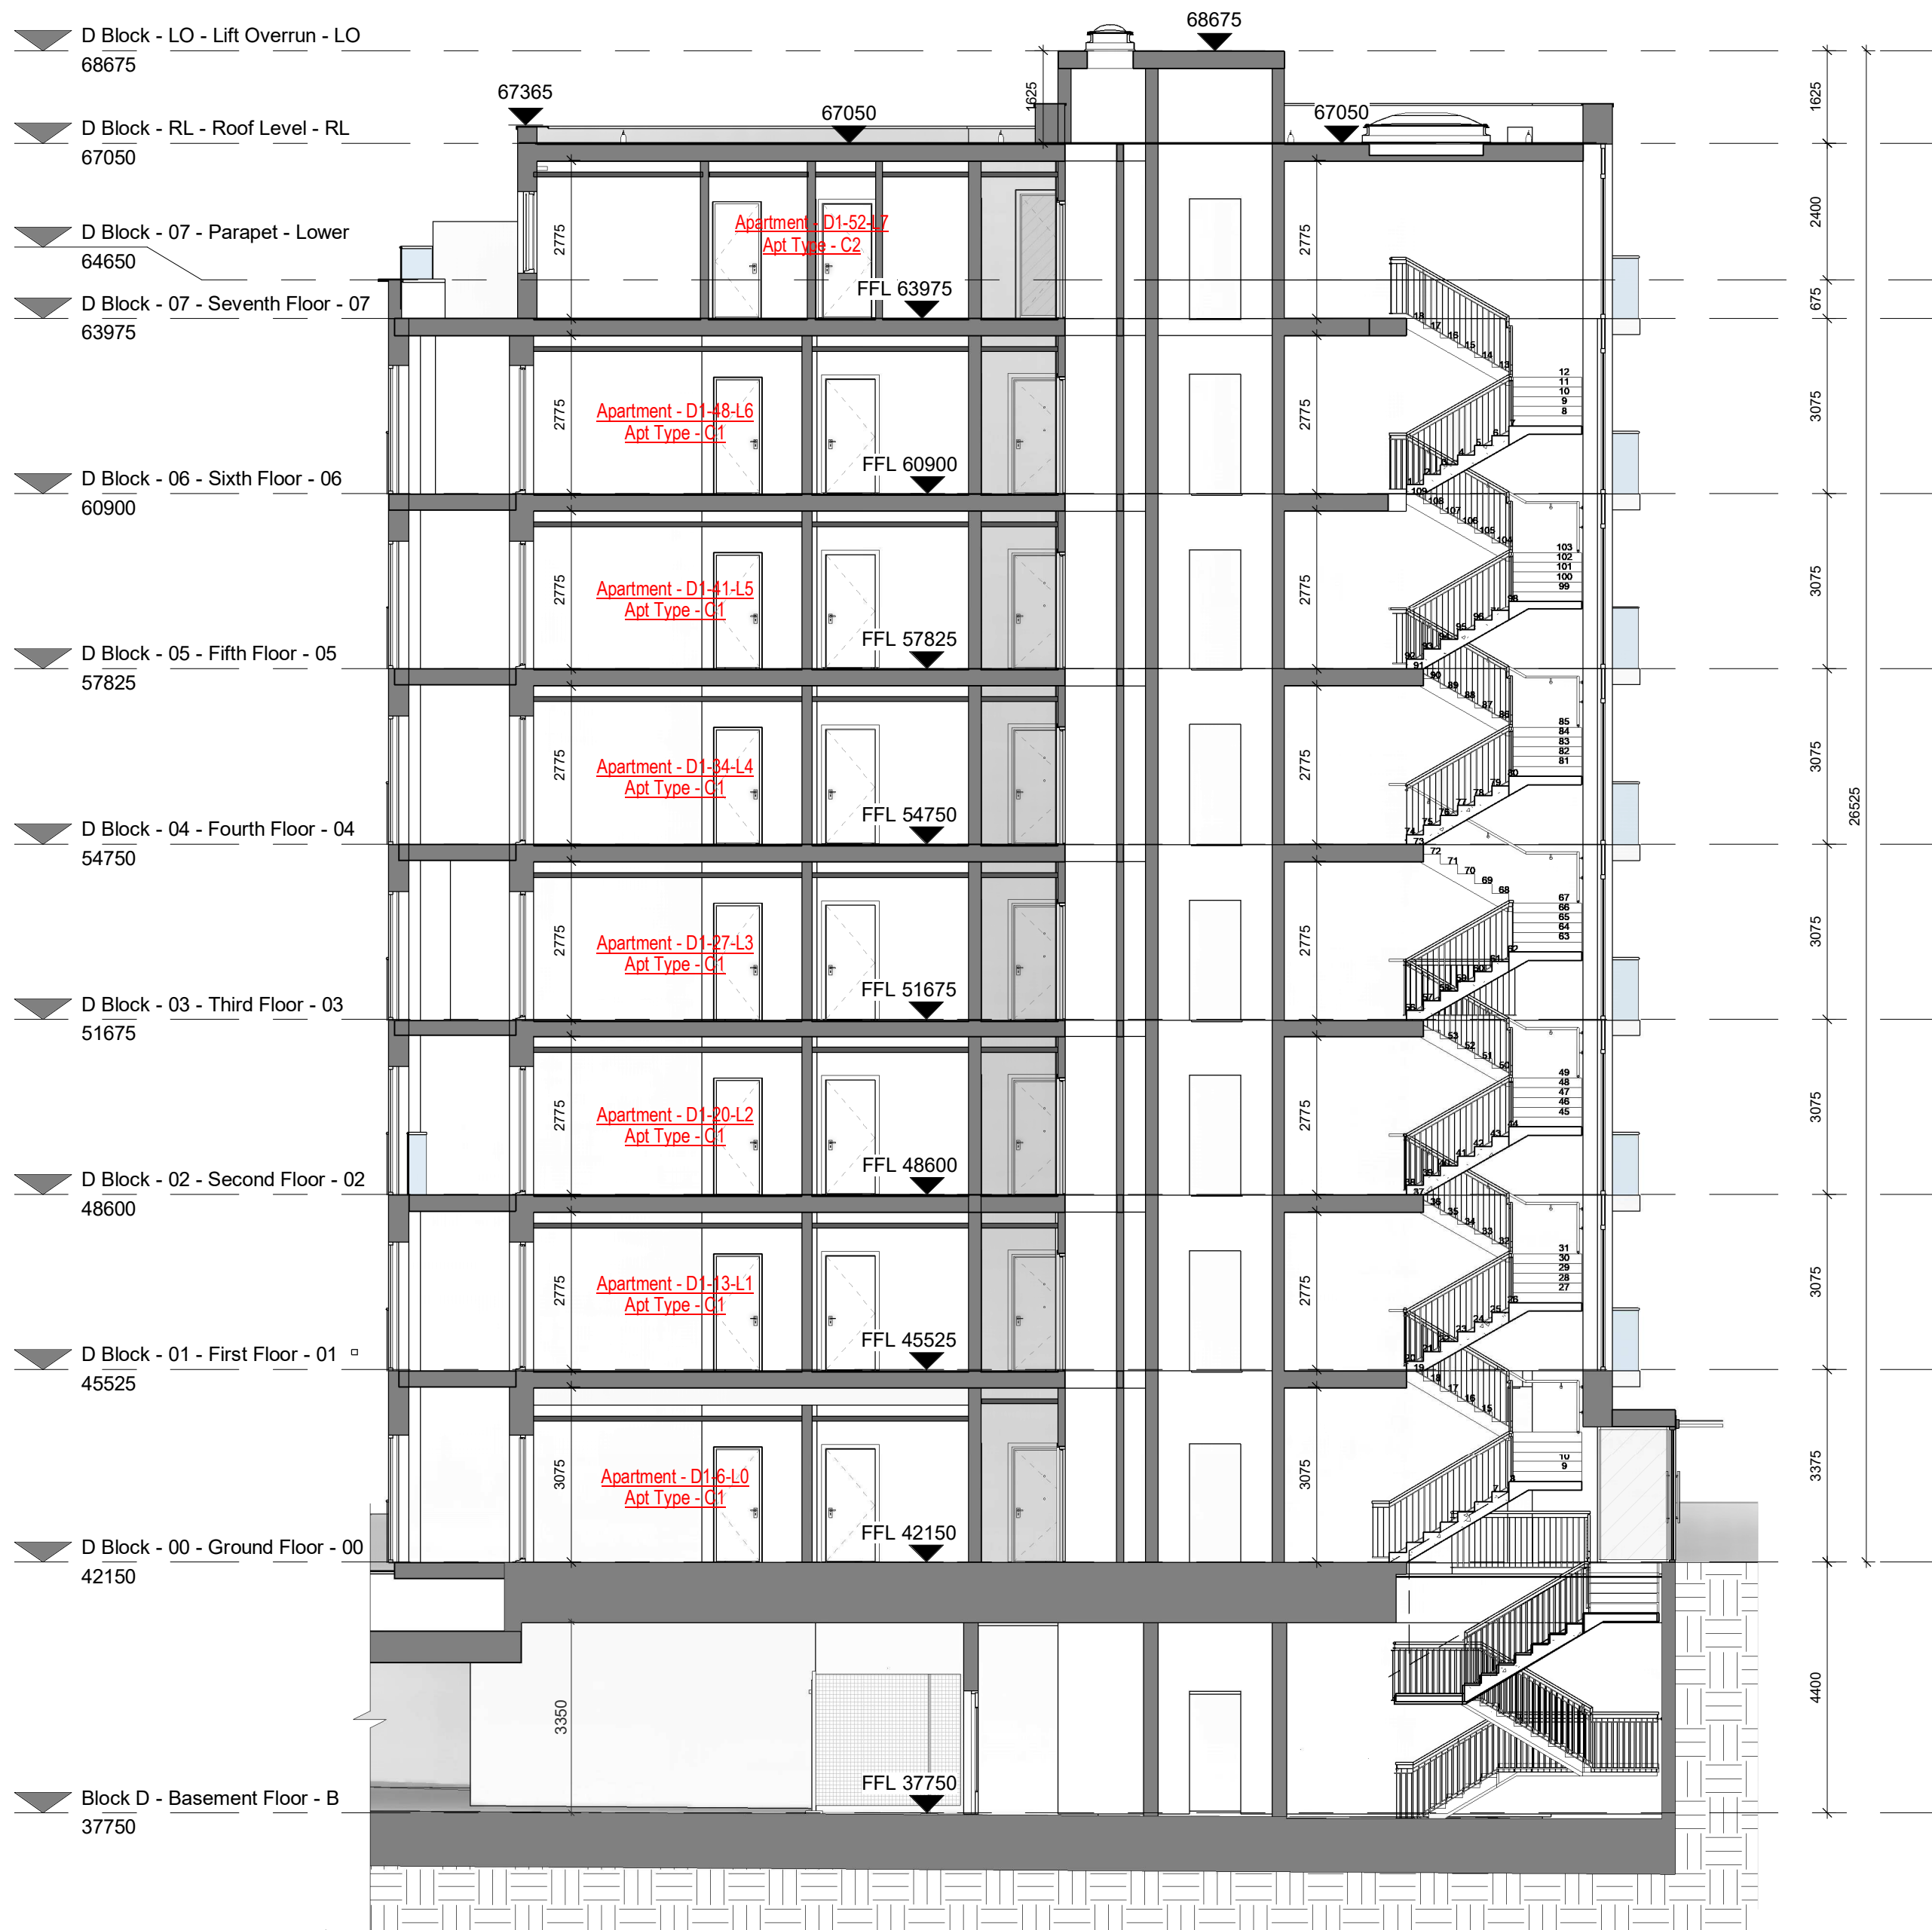

1 GA - Section BB

1 : 100

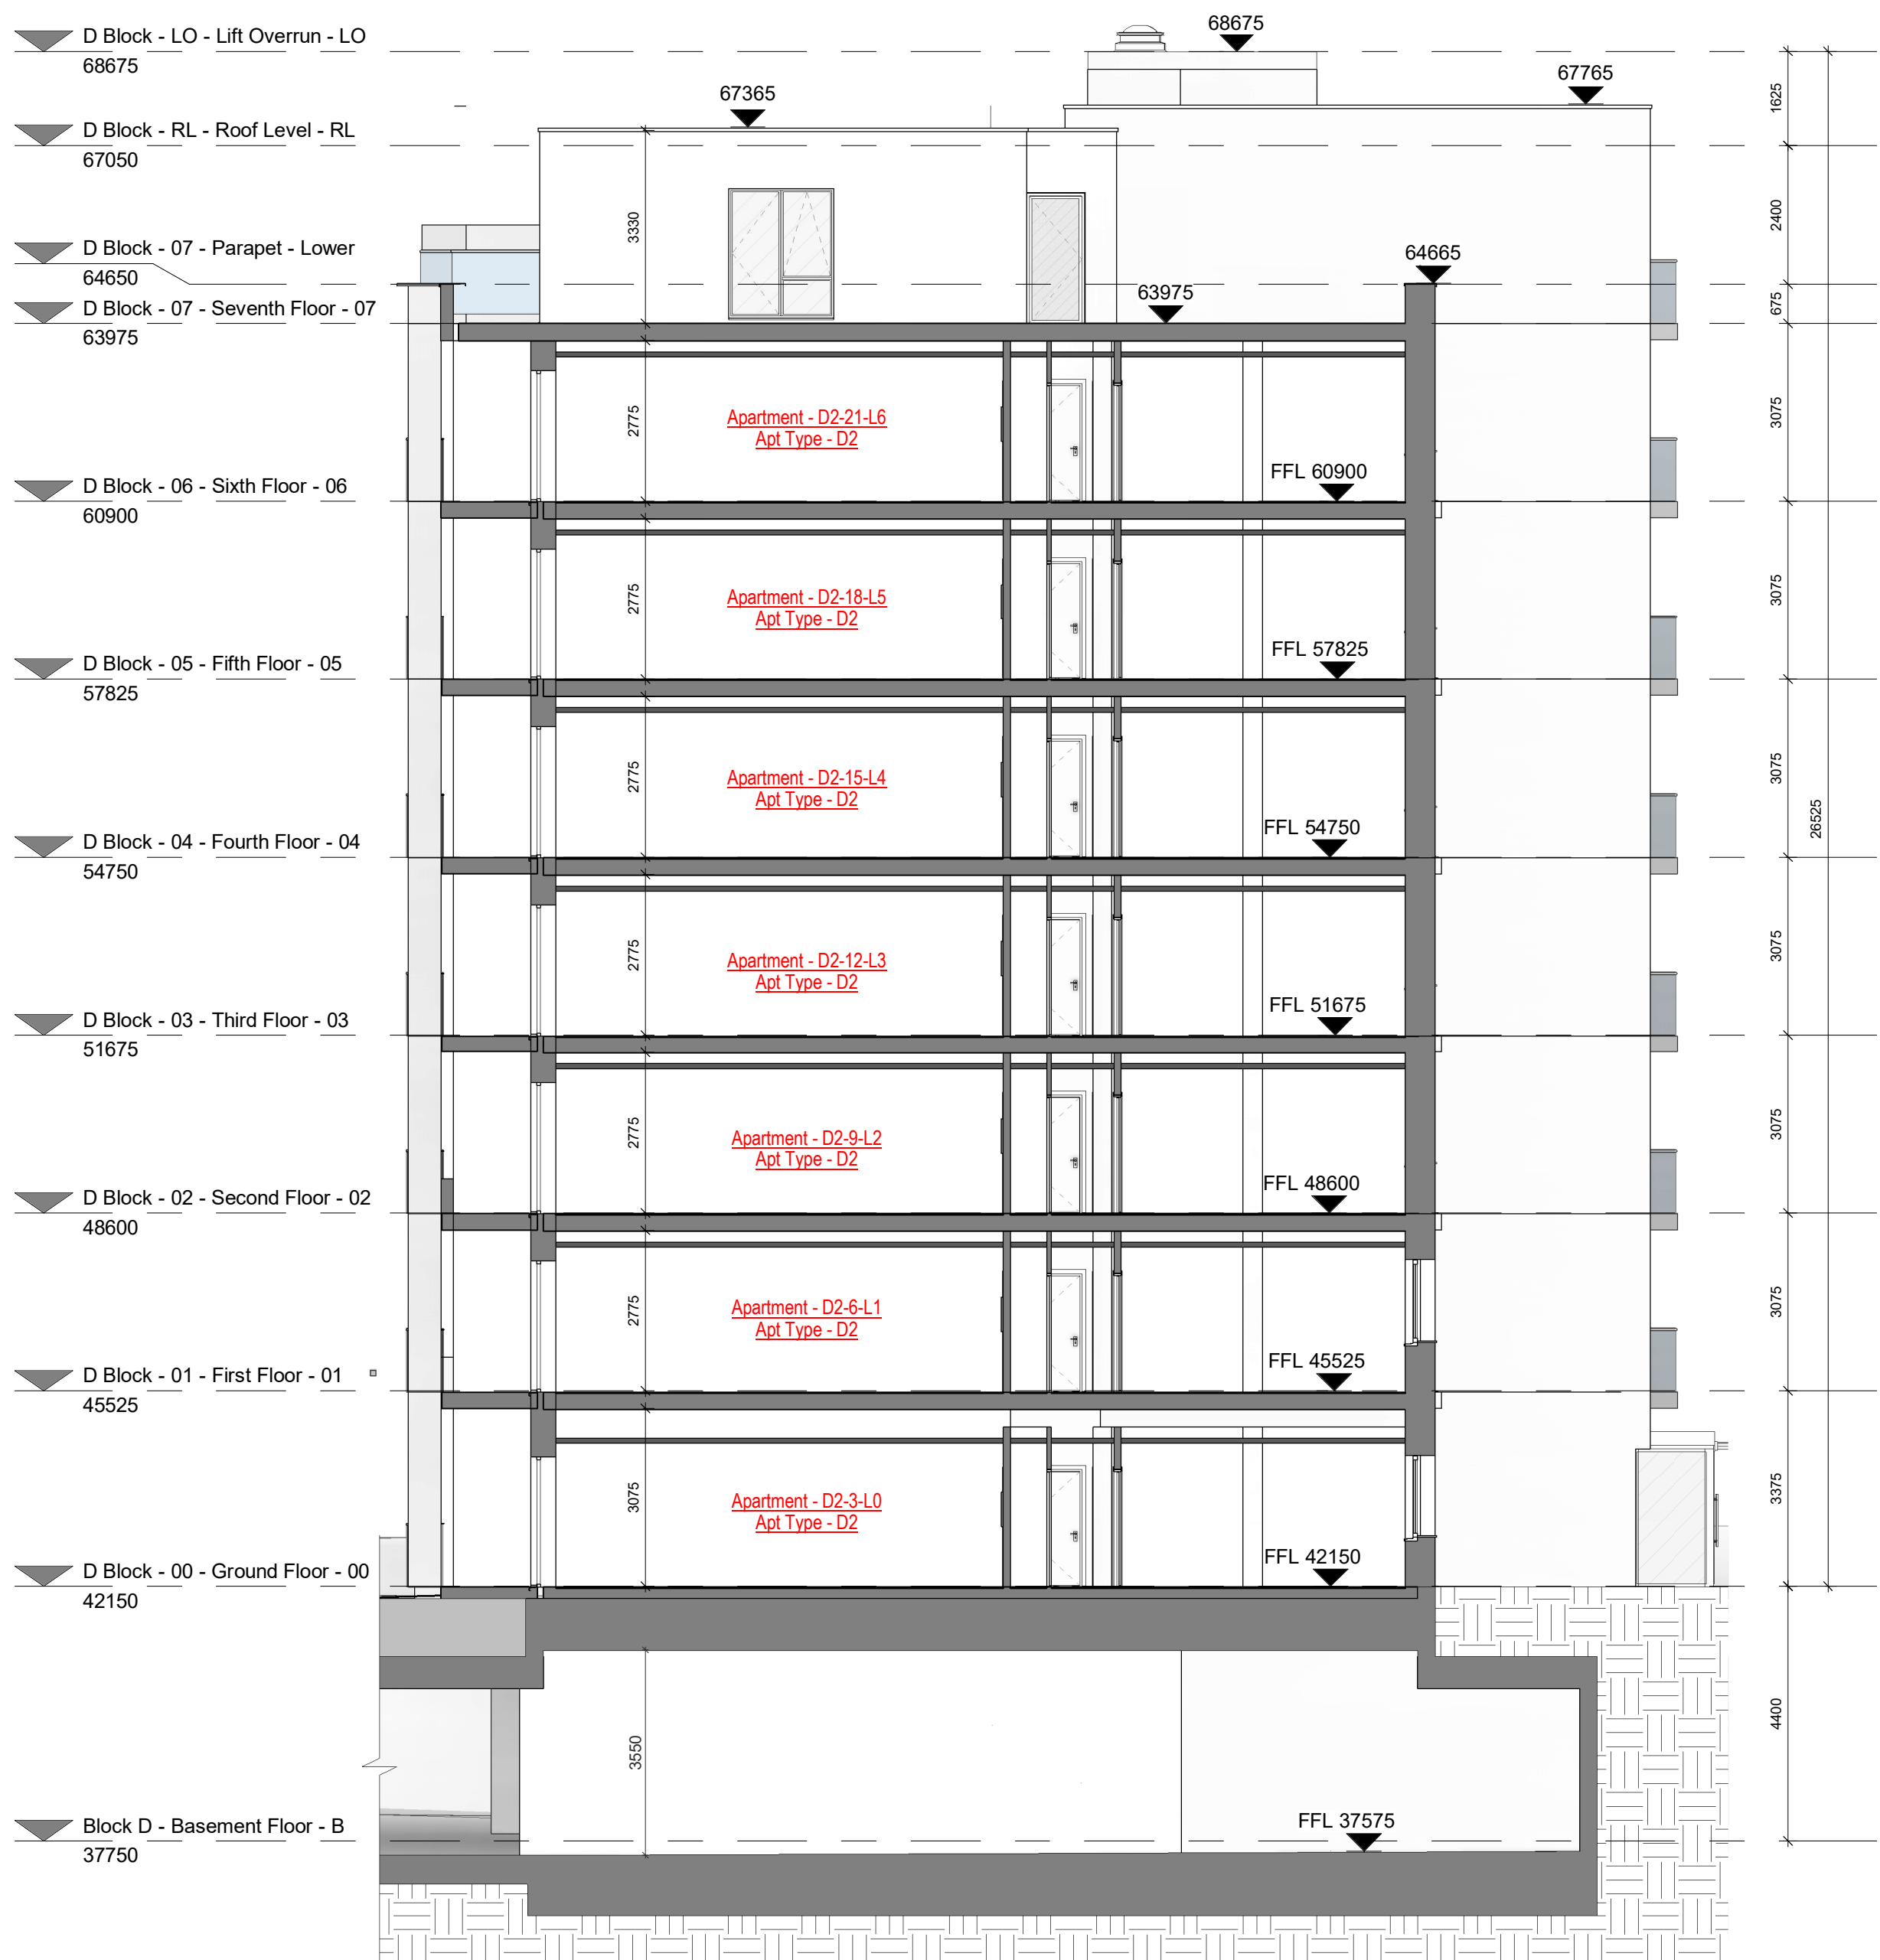

2 GA - Section CC

1 : 100