


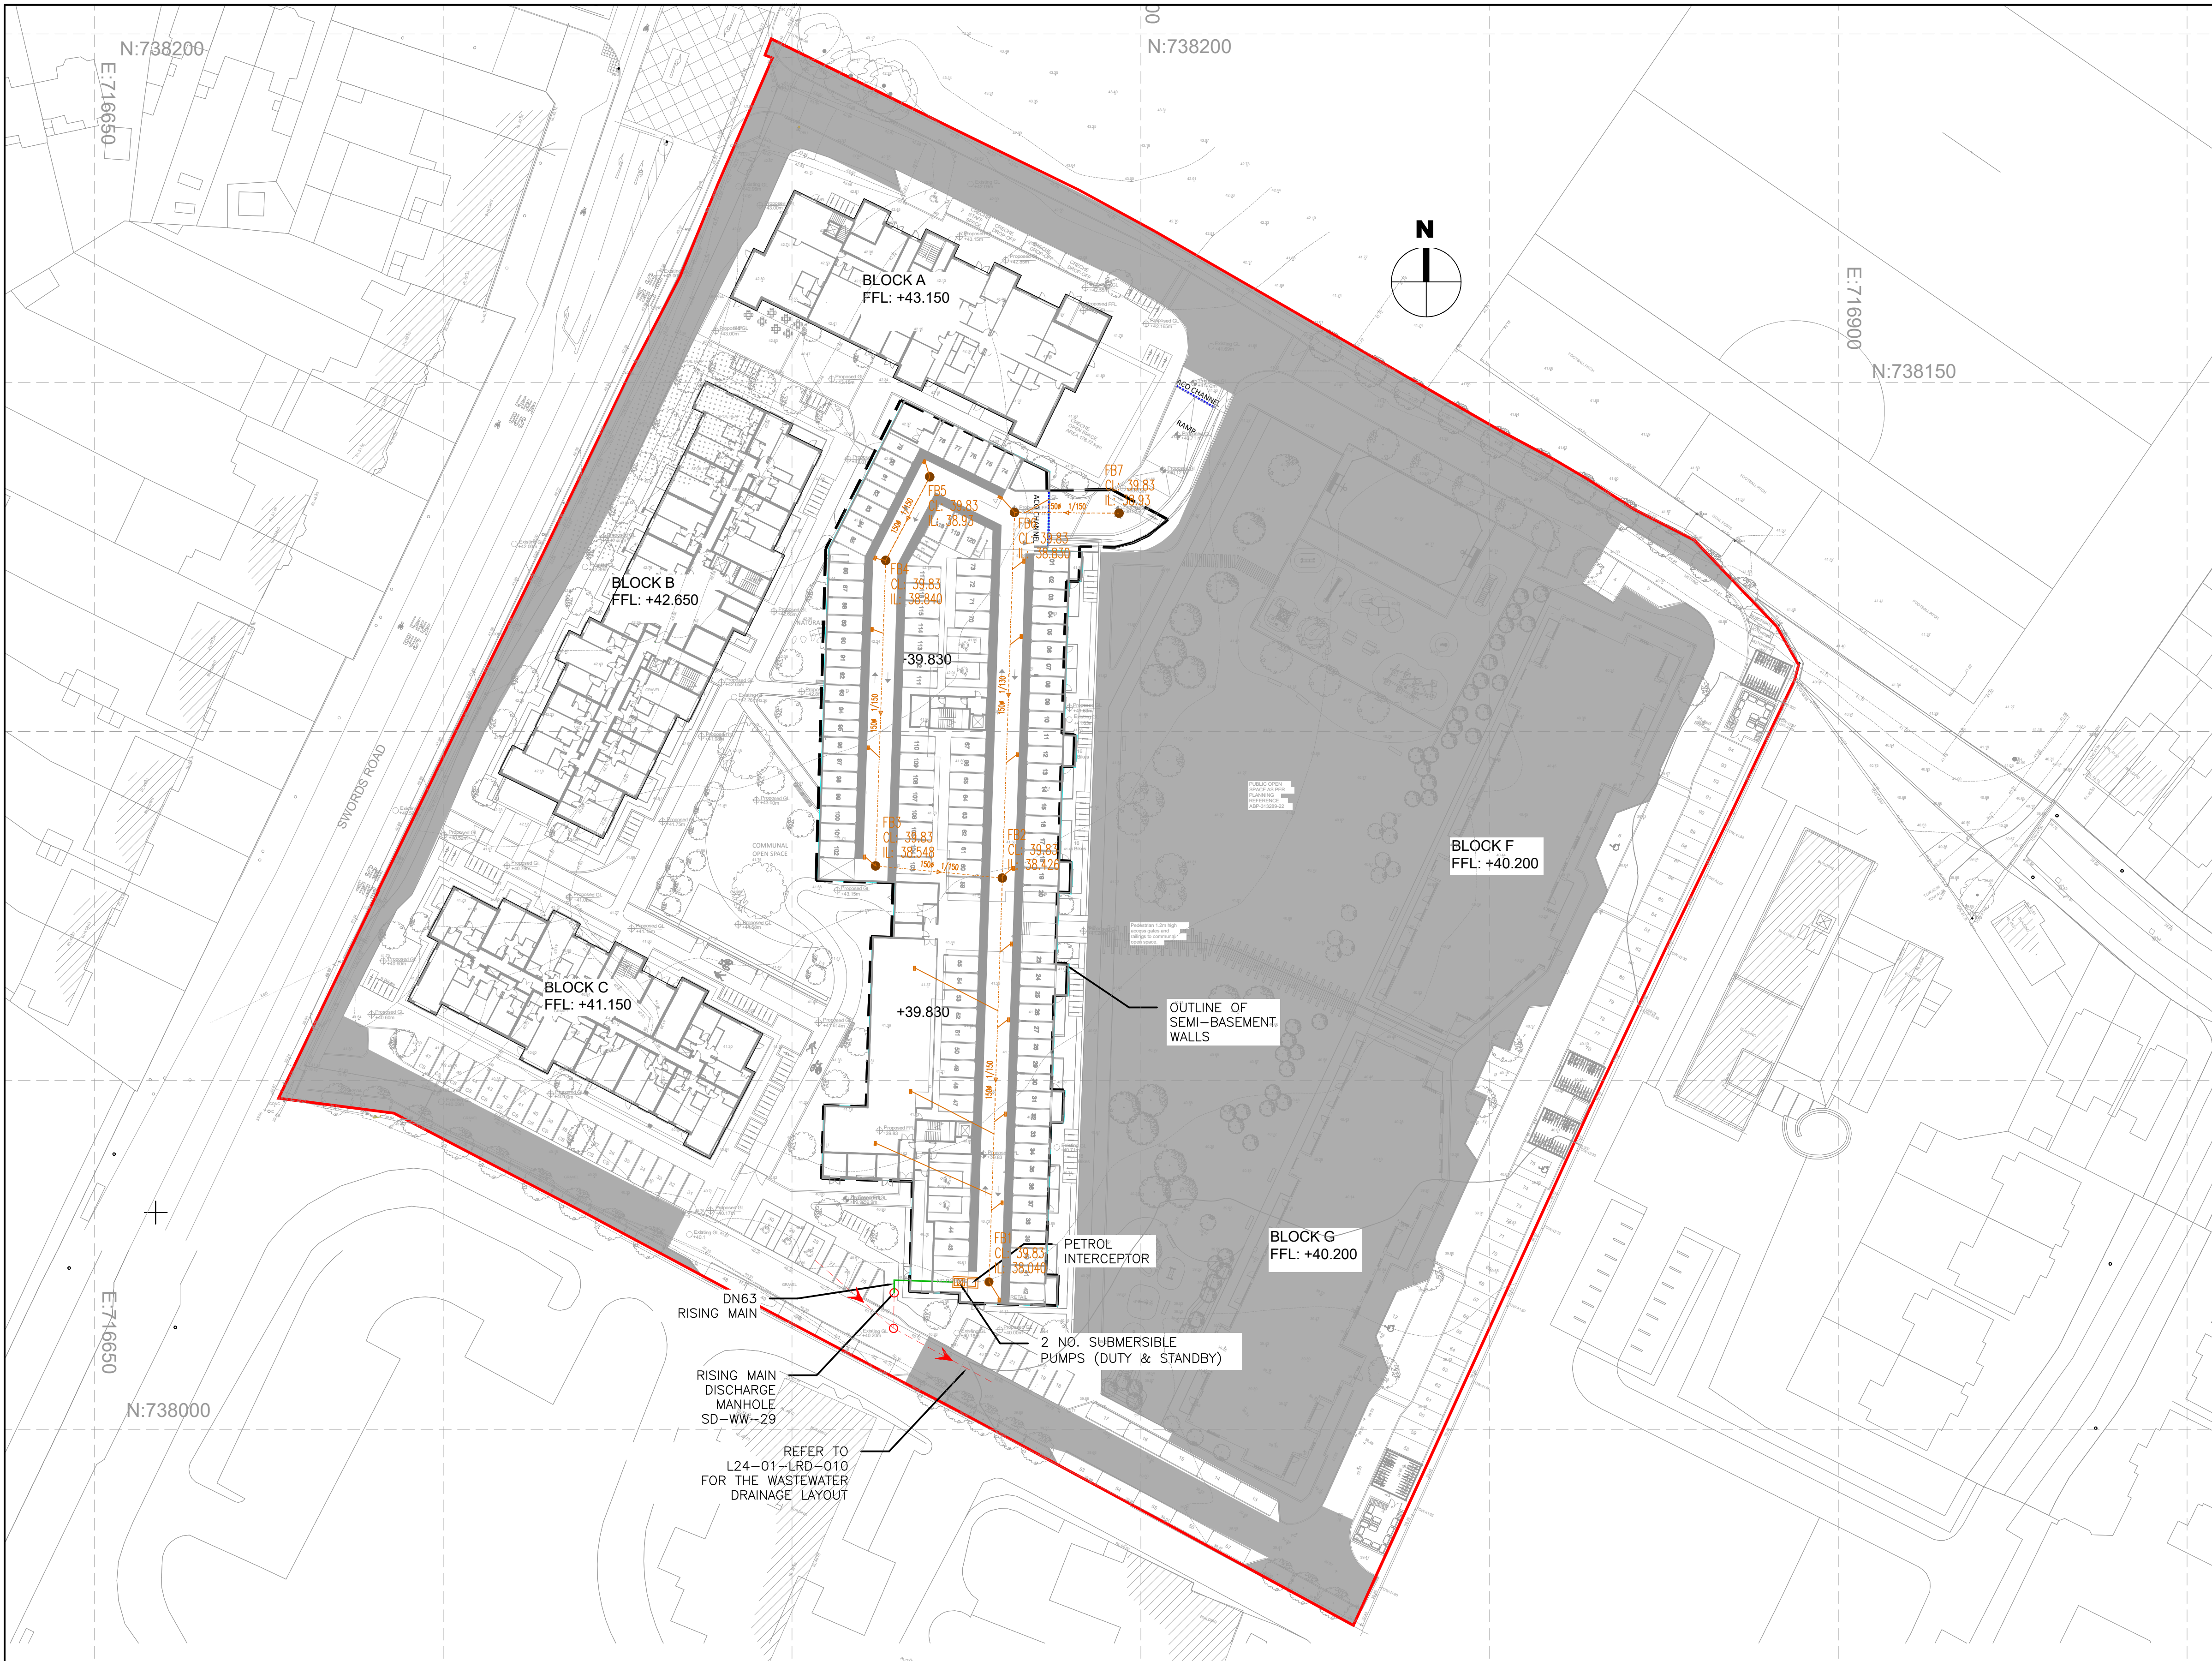

- APPLICATION SITE BOUNDARY
- AREA EXCLUDED FROM AMENDMENT APPLICATION
- OUTLINE OF SEMI-BASEMENT

NOTE:
READ IN CONJUNCTION WITH THE LATEST AVAILABLE
• ARCHITECTS GA PLANS, SECTIONS & ELEVATIONS
• ALL RELEVANT LANDSCAPE'S, STRUCTURAL ENGINEER'S & M&E CONSULTANT'S DRAWINGS & SPECIFICATIONS.

issued for
PLANNING

DIMENSIONS

Figured dimensions only to be taken from this drawing.
All dimensions to be checked on site.
Architects to be informed immediately of any discrepancies before work proceeds.

© COPYRIGHT

This drawing and any design hereon is copyright of
JOR Consulting Engineers and must not be reproduced
in whole or in part without their express written consent.

LEGEND

S44
CL: 39.978
IL: 38.42



PROPOSED BASEMENT DRAINAGE



PROPOSED BASEMENT SURFACE GULLY

REV	DATE	DETAILS
1	23.09.24	Issued for LRD application
0	AUG.24	Draft issue



CLIENT
EW Property Ltd

PROJECT
Hartfield Place,
Swords Road, Whitehall,
Dublin 9, D09 C7F8

TITLE
LRD:
Semi-Basement Drainage Layout

SCALE
1:500 @ A1

DATE CREATED
Sept 2024

DRAWN BY:
LS

CHECKED BY:
JOR

L24-01-LRD-021

REV
1