


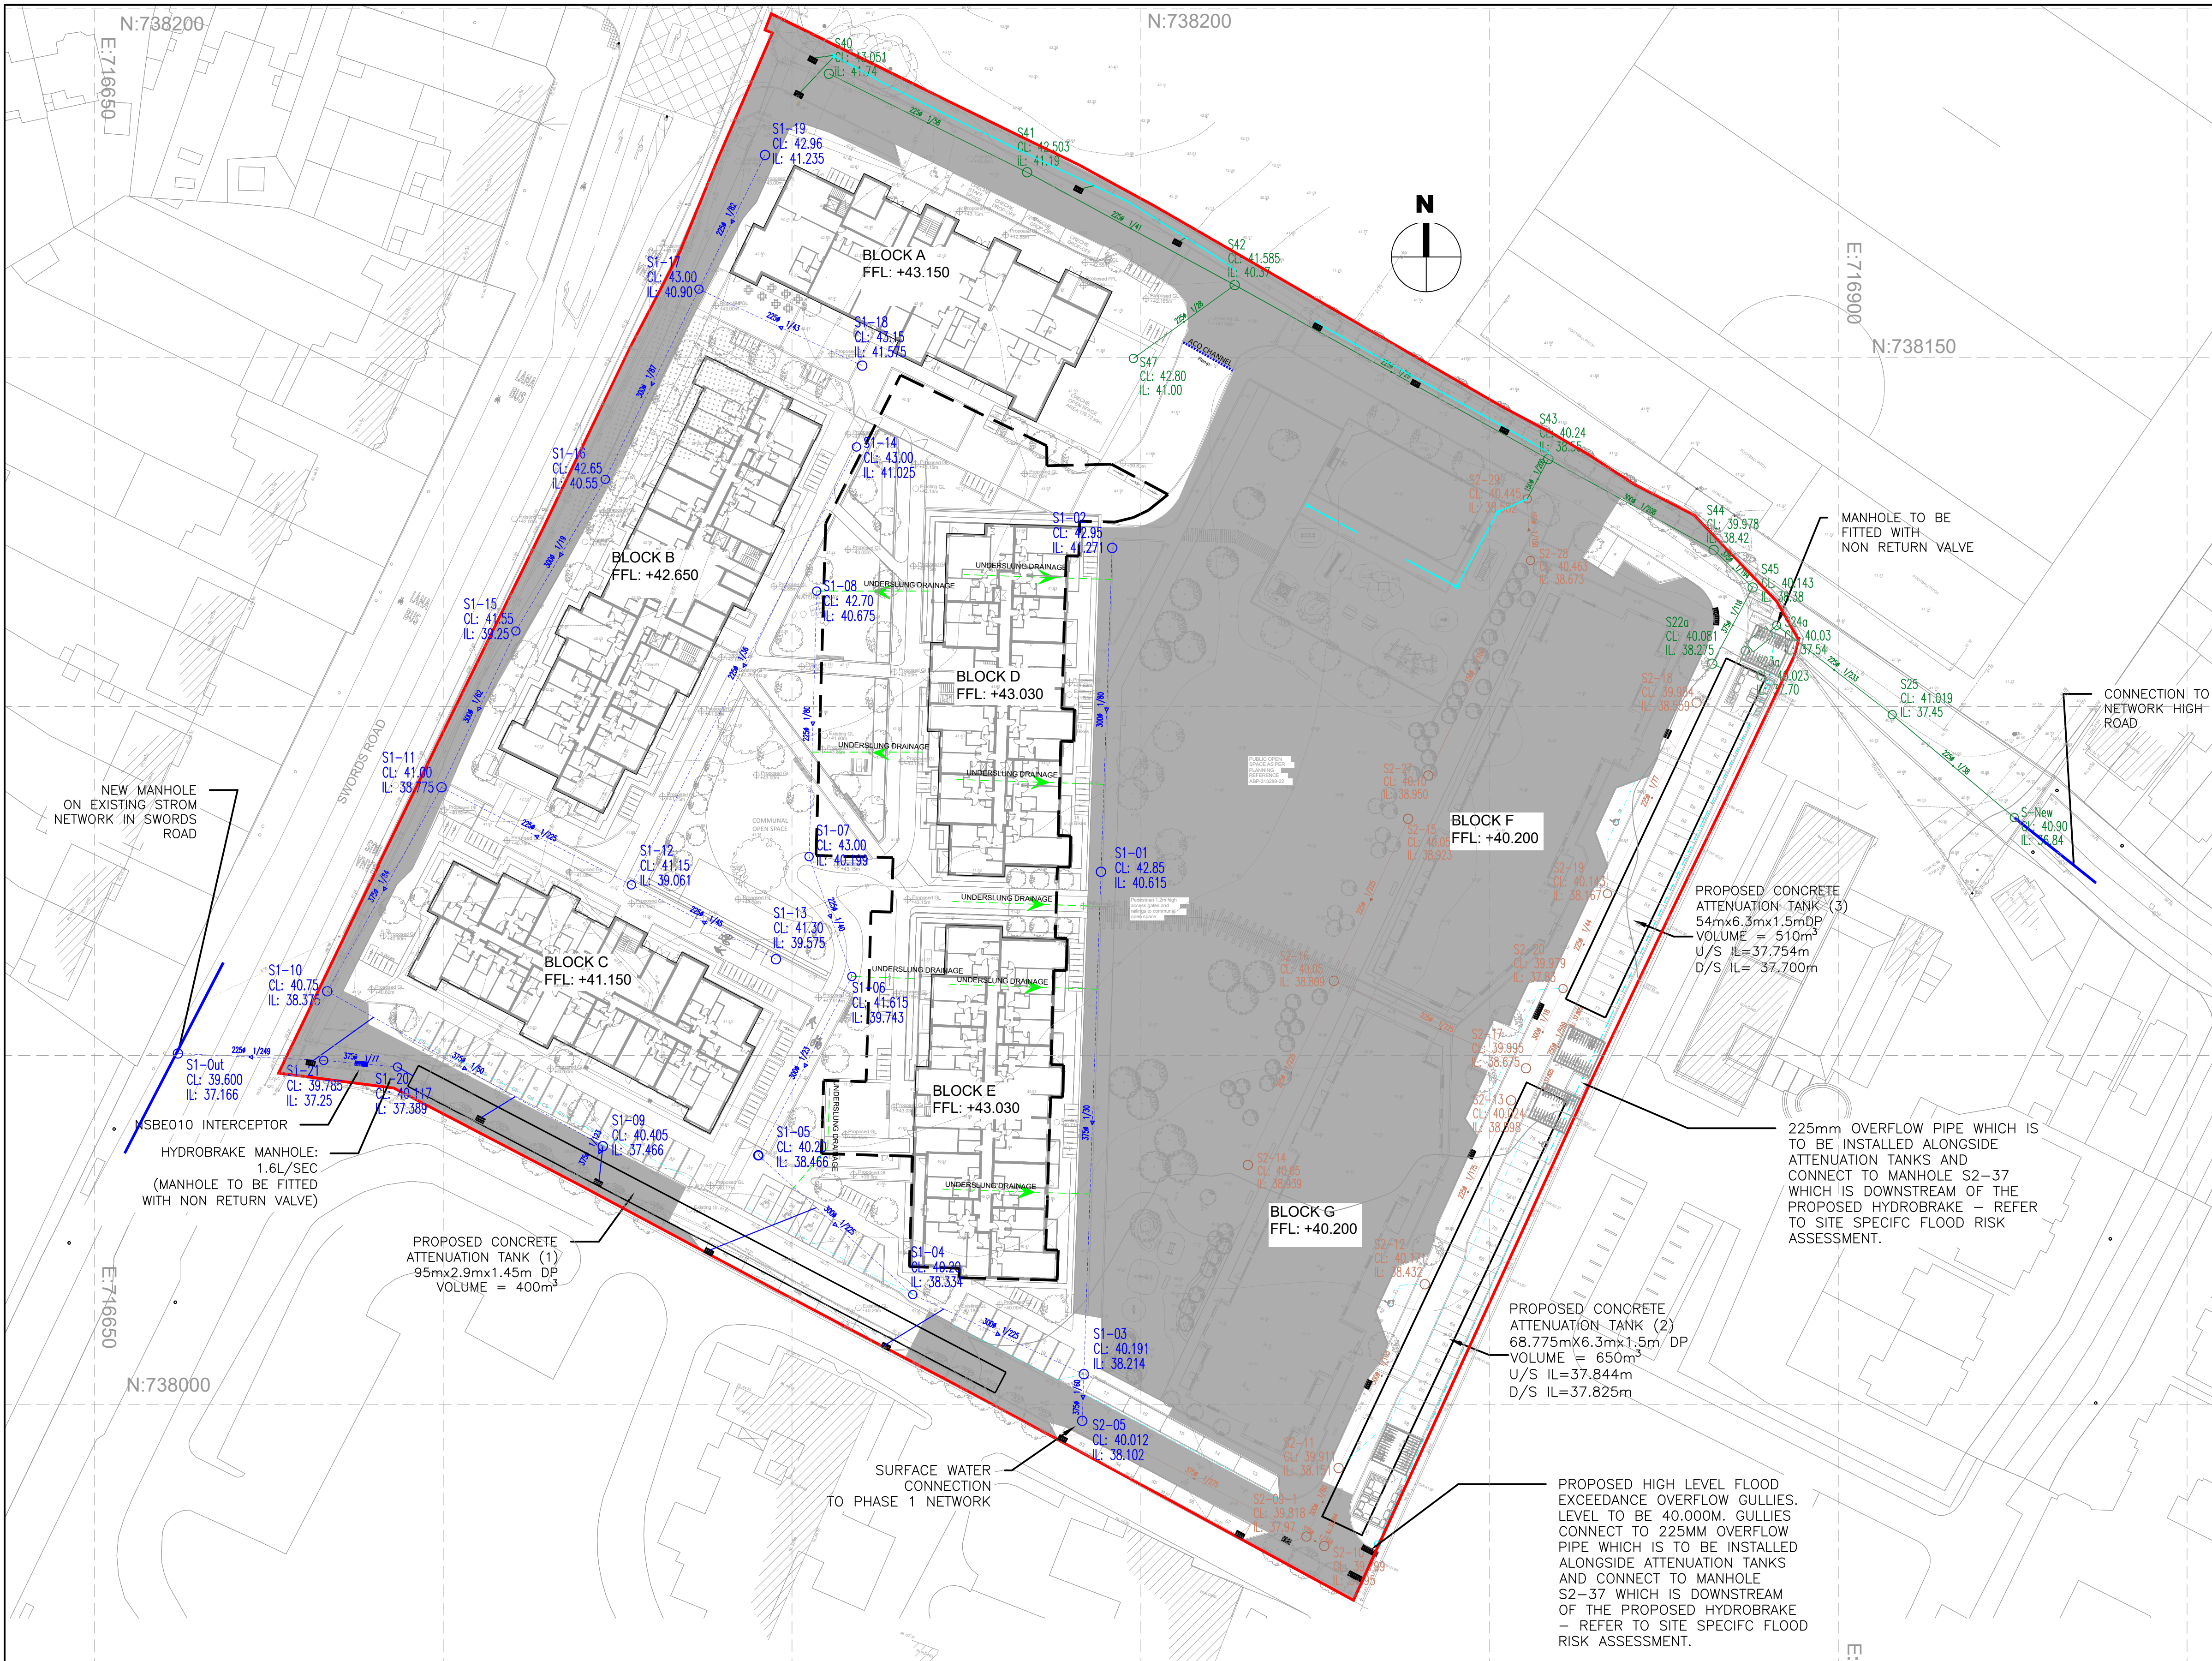

- APPLICATION SITE BOUNDARY
- AREA EXCLUDED FROM AMENDMENT APPLICATION
- - - OUTLINE OF SEMI-BASEMENT

NOTE:
READ IN CONJUNCTION WITH THE LATEST AVAILABLE
• ARCHITECTS GA PLANS, SECTIONS & ELEVATIONS
• ALL RELEVANT LANDSCAPE'S, STRUCTURAL ENGINEER'S & M&E CONSULTANT'S DRAWINGS & SPECIFICATIONS.

issued for
PLANNING

DIMENSIONS

Figured dimensions only to be taken from this drawing.
All dimensions to be checked on site.
Architects to be informed immediately of any discrepancies before work proceeds.

© COPYRIGHT

This drawing and any design hereon is copyright of JOR Consulting Engineers and must not be reproduced in whole or in part without their express written consent.

LEGEND

S2-06
CL: 40.014
IL: 38.102

S44
CL: 39.978
IL: 38.42

S44
CL: 39.978
IL: 38.42

PROPOSED SURFACE WATER NETWORK

CONSTRUCTED SURFACE WATER NETWORK

PHASE 1 SURFACE WATER NETWORK

150mm DIA. FILTER DRAIN

PROPOSED CONCRETE ATTENUATION TANK

PROPOSED ROAD SURFACE GULLY

REV	DATE	DETAILS
1	23.09.24	Issued for LRD application
0	AUG.24	Draft issue



CLIENT	EW Property Ltd	TITLE	LRD: Storm Water Drainage Layout
PROJECT	Hartfield Place, Swords Road, Whitehall, Dublin 9, D09 C7F8	SCALE	1:500 @ A1
		DATE CREATED	Sept 2024
		DRAWN BY:	LS
		CHECKED BY:	JOR
		REV	1
		L24-01-LRD-020	